



Table of Contents

1	Floor Plan
2	Basilica Plan
3	Column Plan
4	Tower Plan & Section
5	Section - Front
6	Section - Side
7	Details - Trough
8	Control Drawing
9	Isometric Views

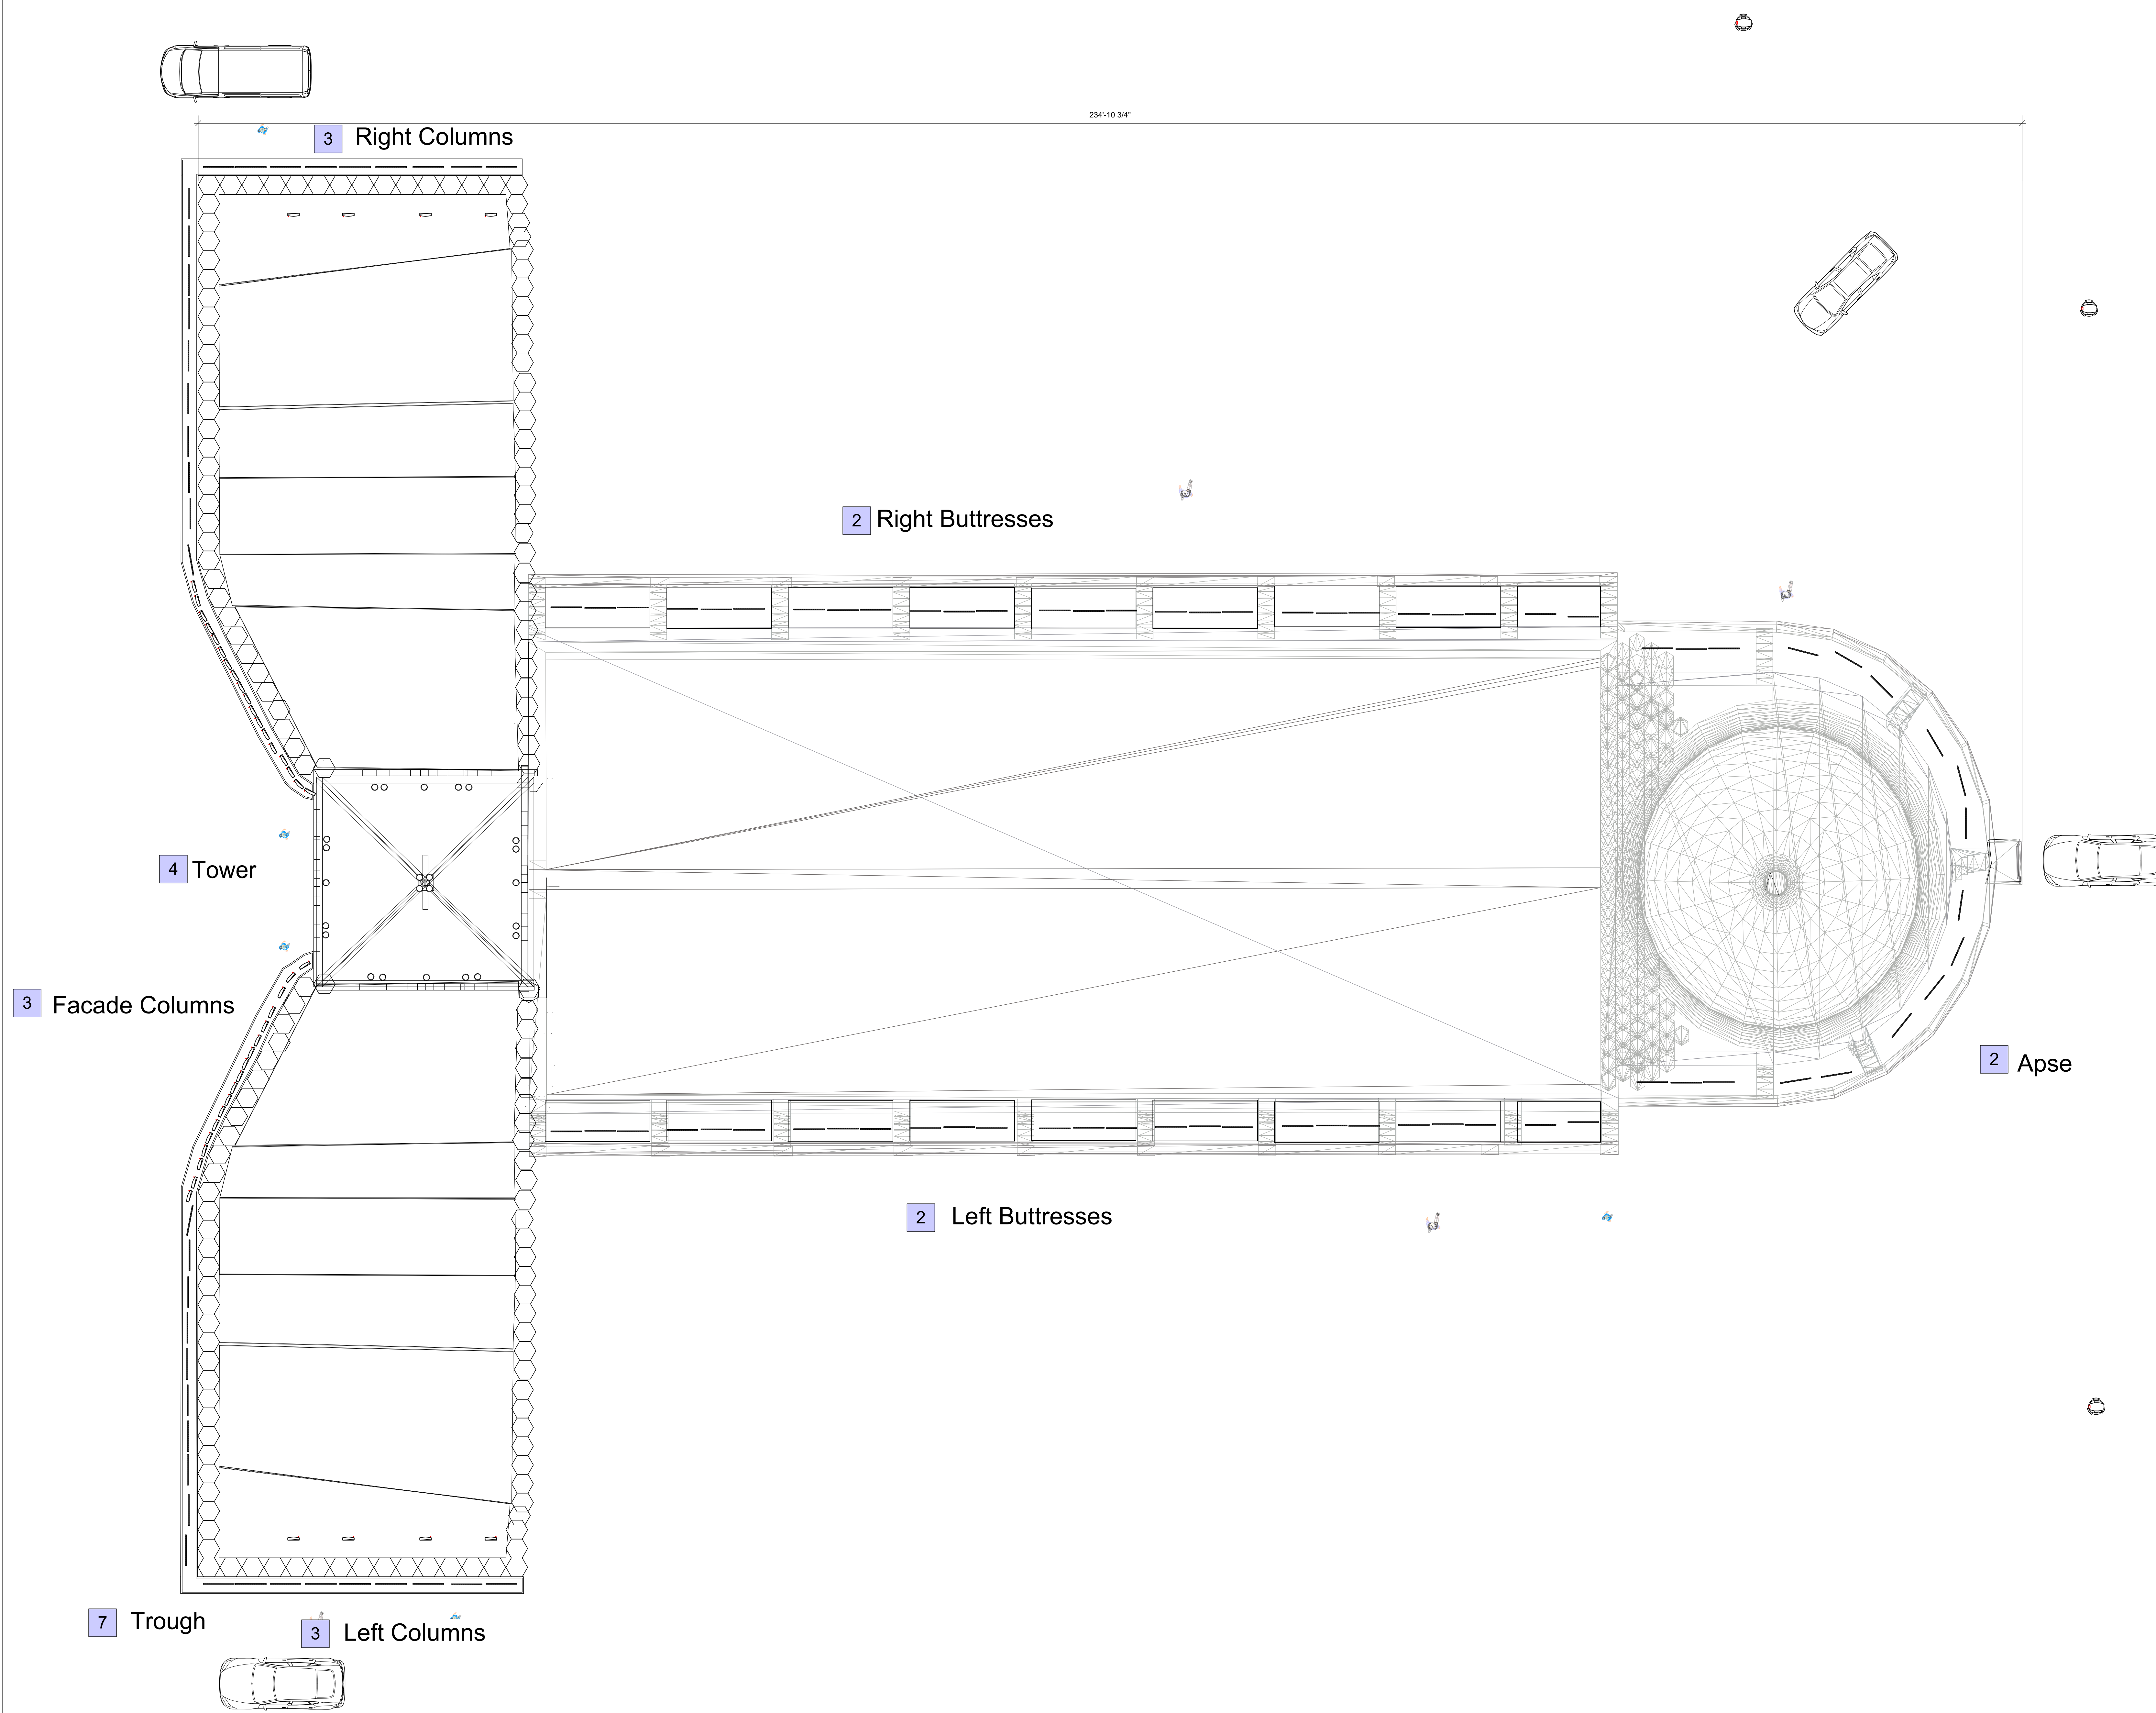


Table of Contents

- 1 Floor Plan
- 2 Basilica Plan
- 3 Column Plan
- 4 Tower Plan & Section
- 5 Section - Front
- 6 Section - Side
- 7 Details - Trough
- 8 Control Drawing
- 9 Isometric Views

Key

- ProPoint RGBW Wall Washer 40W
- Allegro Linear AC 1200
- SGM I-5
- SGM G-Spot Turbo POI

No.	Date	Issue Notes
D	12/10/20	Finalized Package
C	11/20/20	90% Finalized Package



Design Firm: Kahkonen, Smith and Uncein

Project Title: Hallgrimskirkja

Sheet Title: Church Plan - Overview



Drawn By: Ullie Kahkonen, Thomas Uncein

Date: 12/15/20


CAD File Name: Hallgrimskirkja Final Drafting Package.vwx

1 of 9

2 Basilica Plan
Scale: 3/16" = 1'-0"

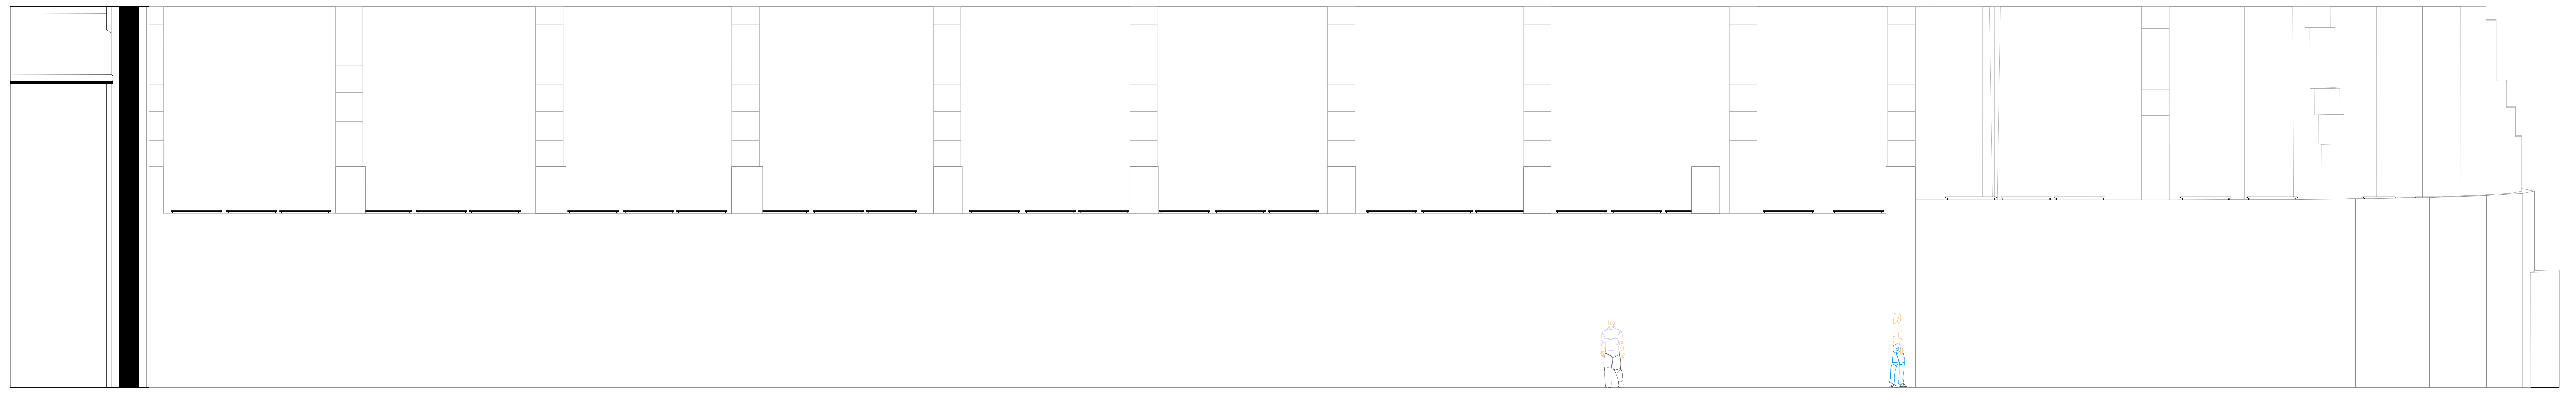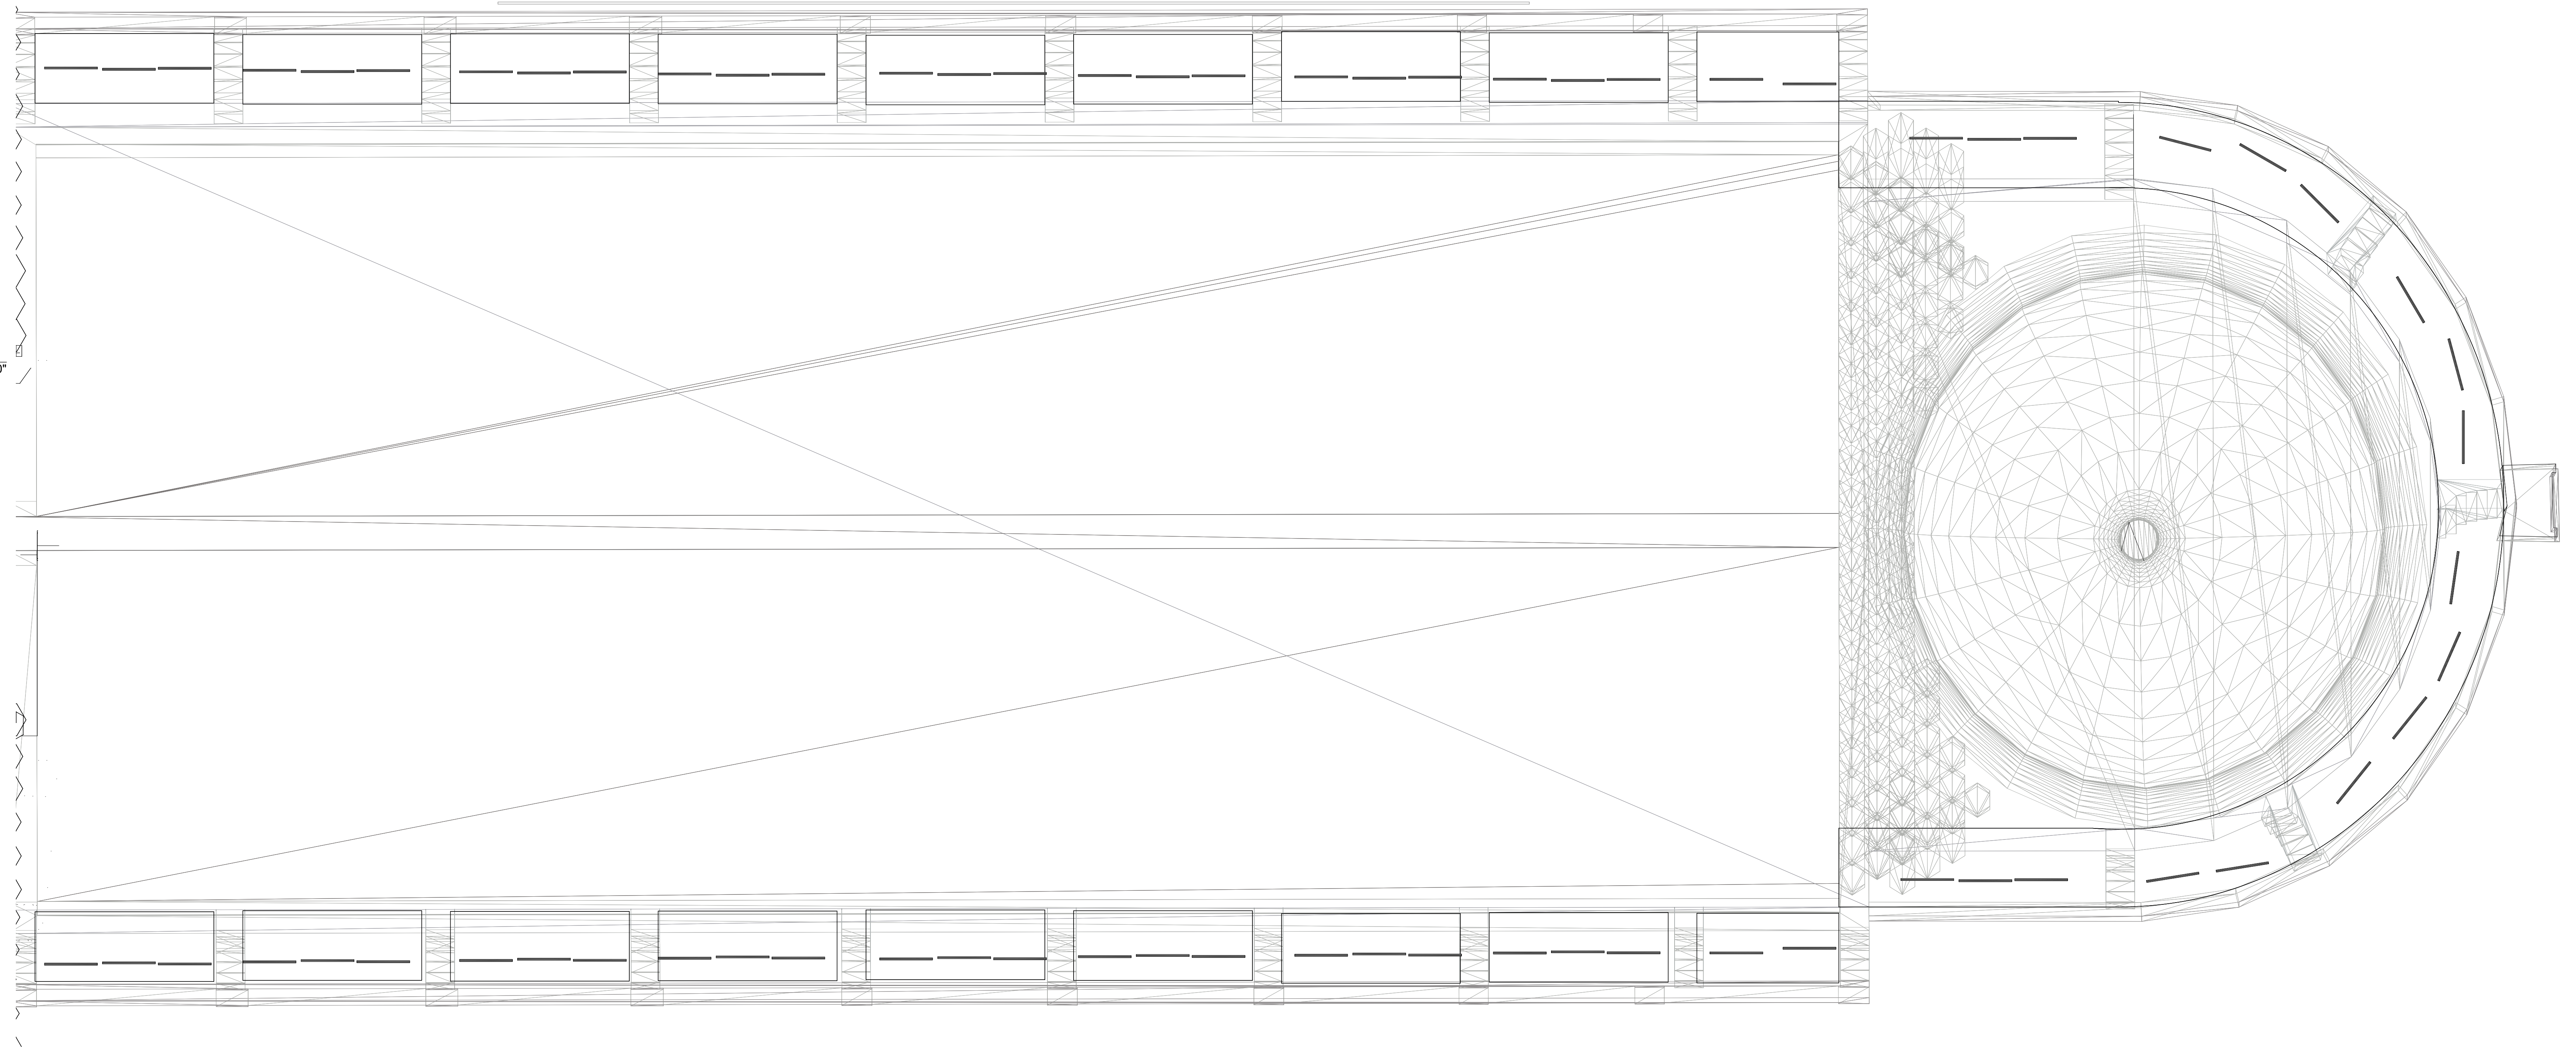

1 Buttress Section
Scale: 3/16" = 1'-0"

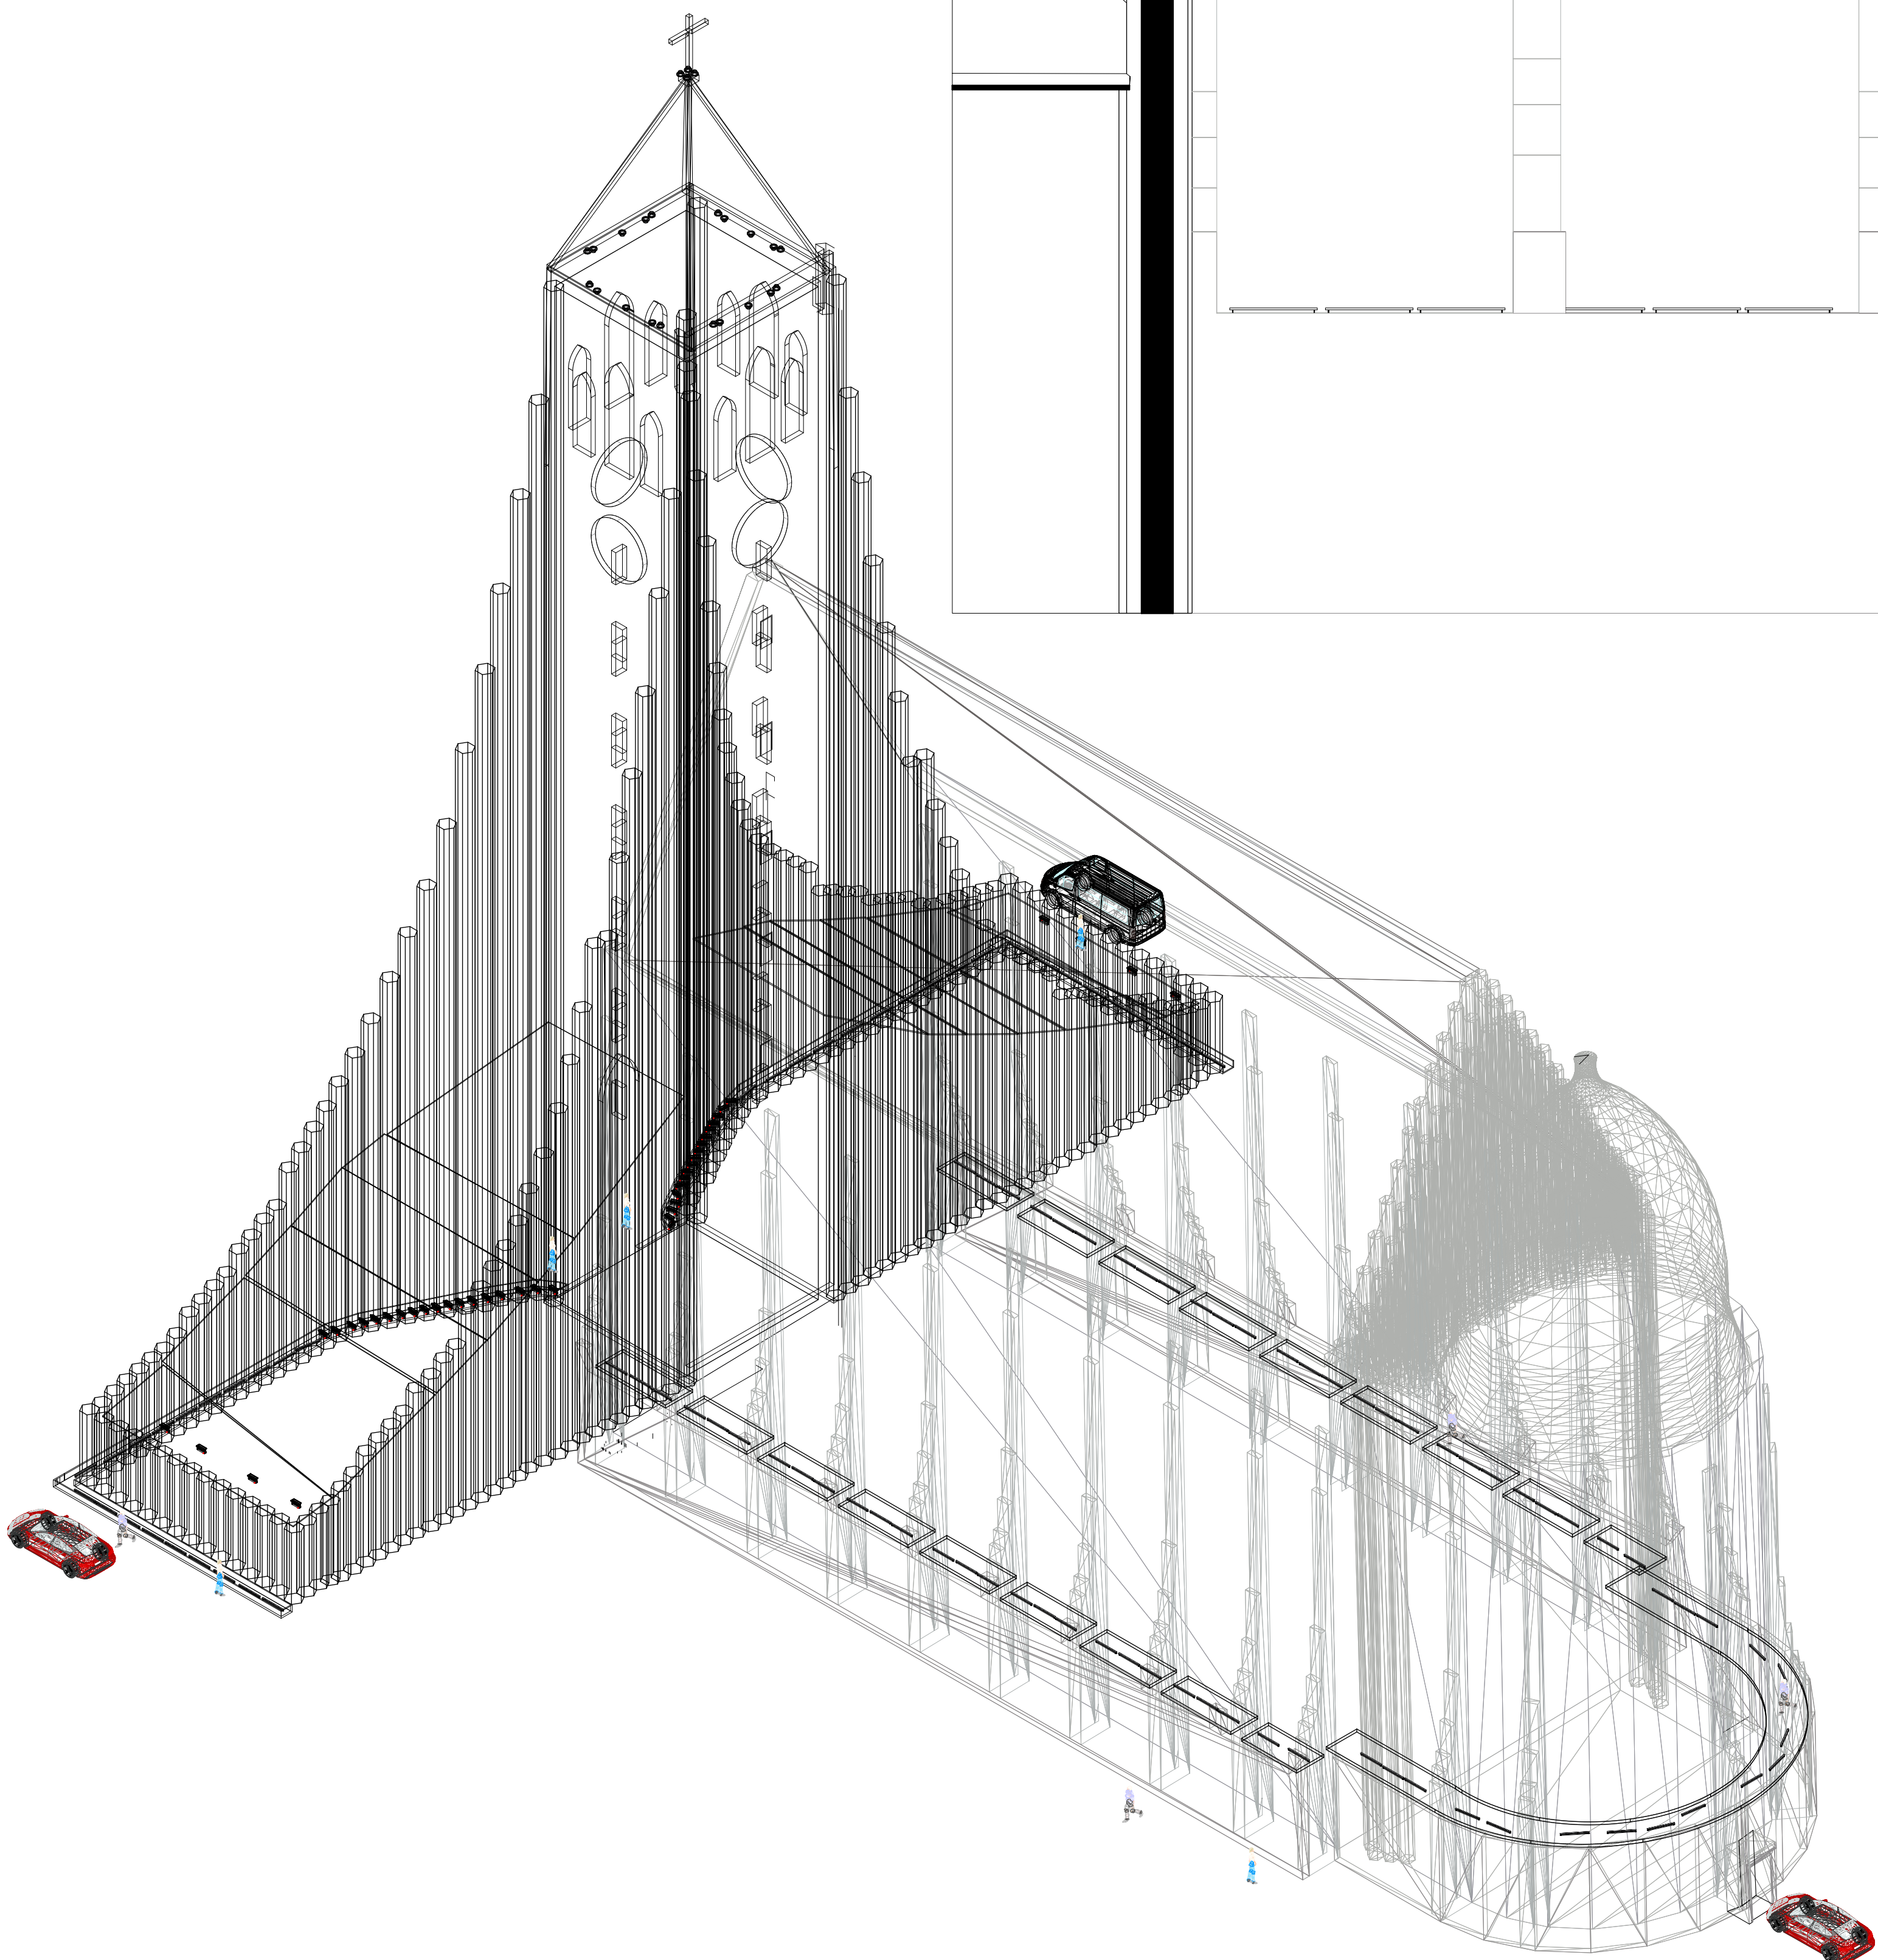

3 Right Isometric
Scale: 1/16" = 1'-0"

- Key**
- ProPoint RGBW Wall Washer 40W
 - Allegro Linear AC 1200
 - SGM I-5
 - SGM G-Spot Turbo POI

No.	Date	Issue Notes
E	11/5/20	





Design Firm: Kahkonen, Smith and Uncein

Project Title: Hallgrimskirkja


Sheet Title: Basilica Plan

Drawn By: Lillie Kahkonen, Thomas Uncein
Date: 12/15/20

CAD File Name: Hallgrimskirkja Final Drafting Package.vwx
2 of 9

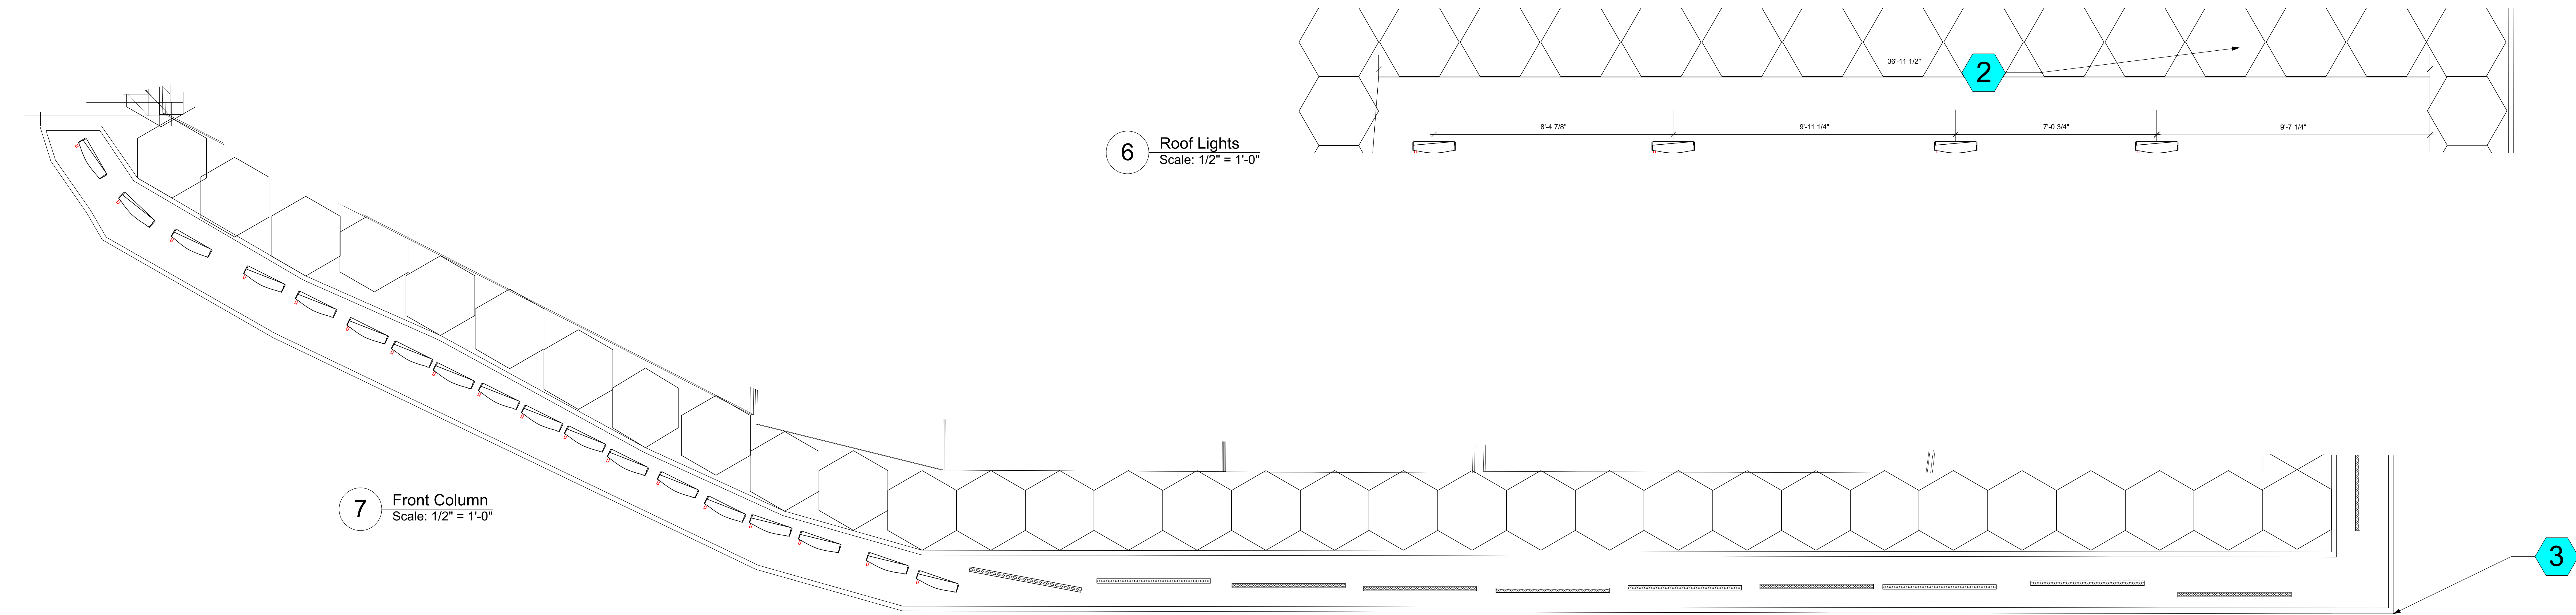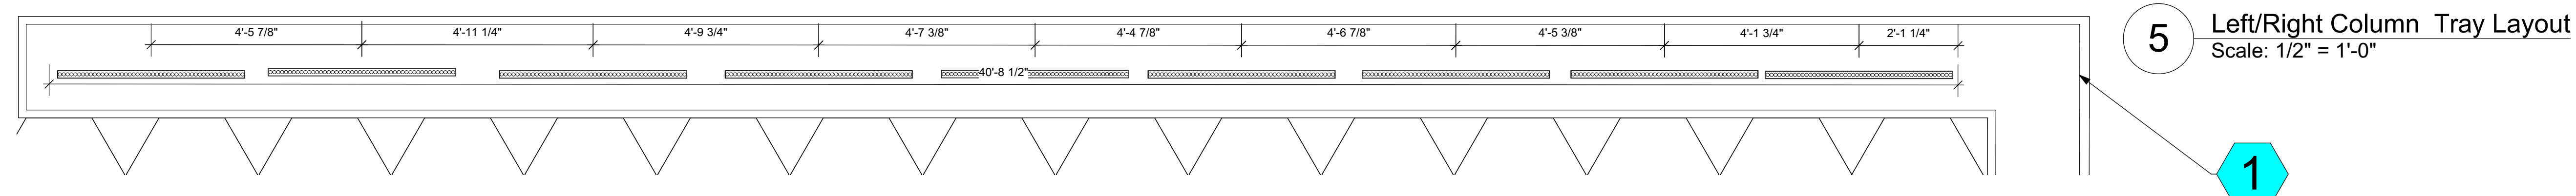


7 Front Column
Scale: 1/2" = 1'-0"

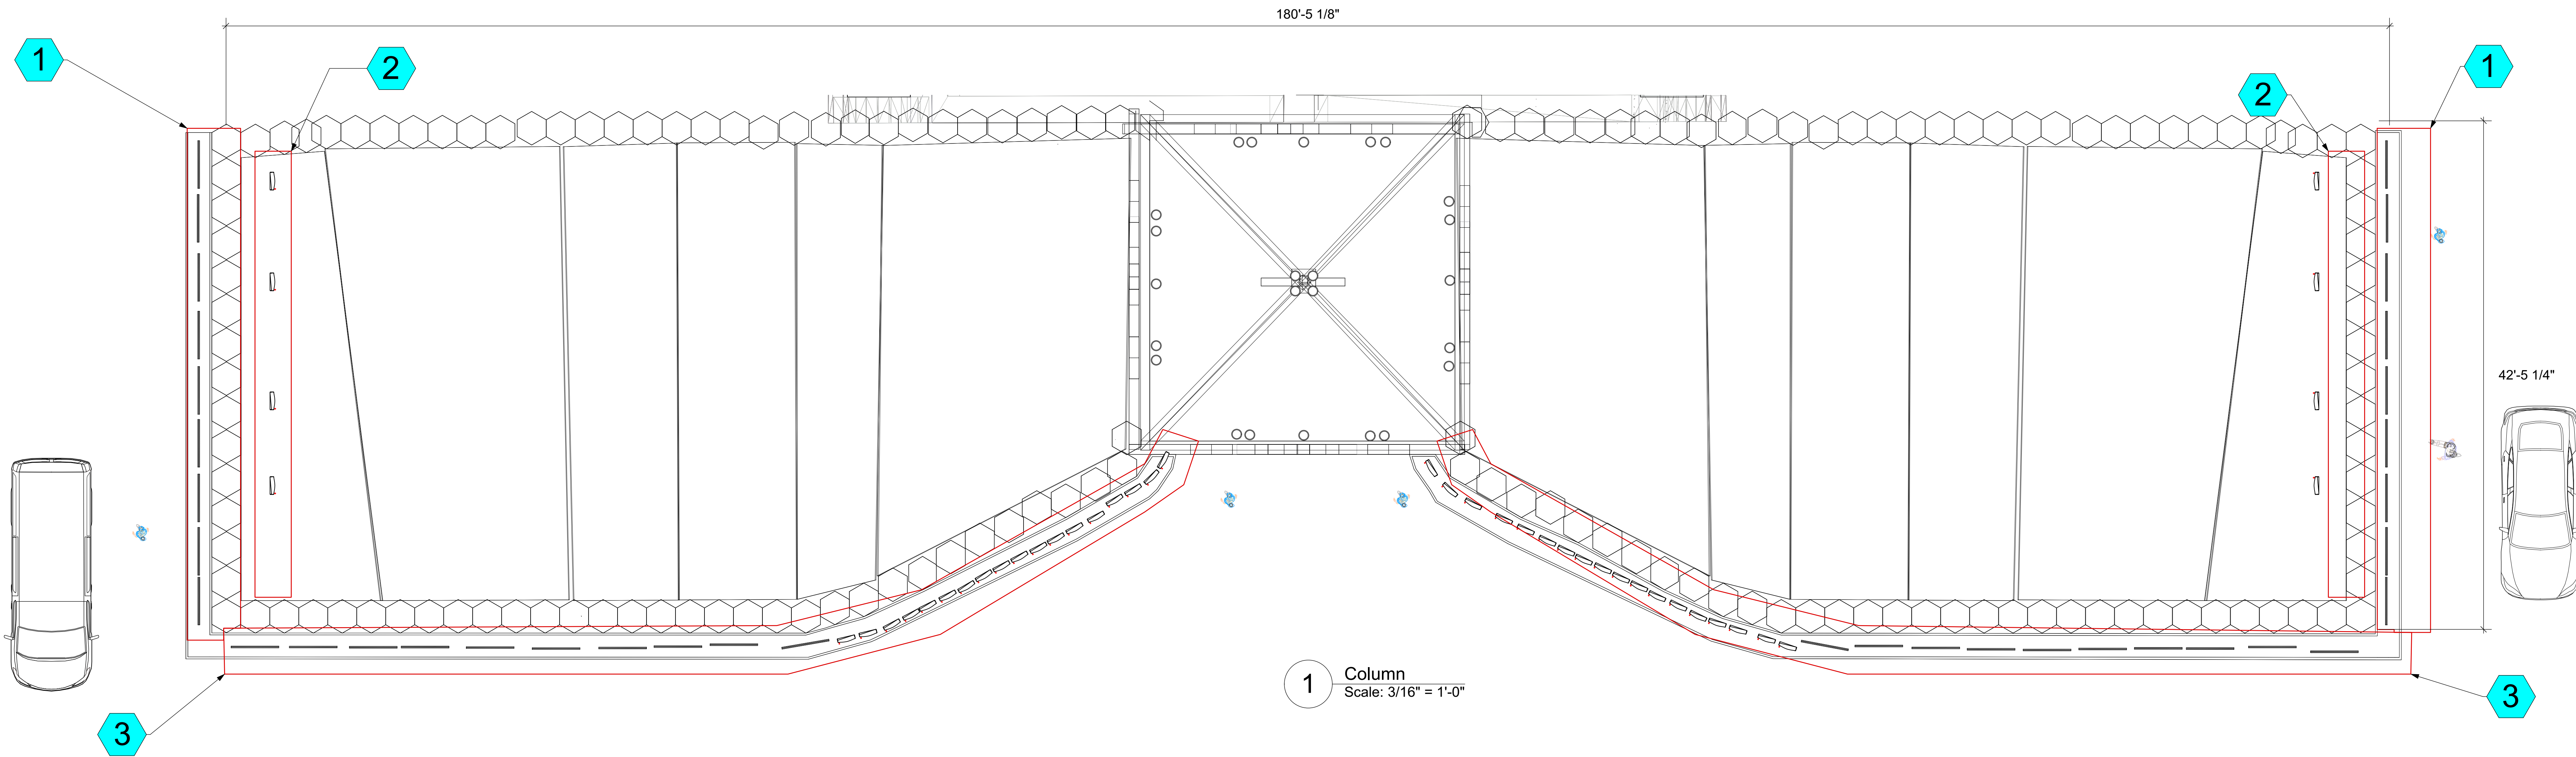


- Notes**
- Side column Lights on the left () and Right (South East) of building are a mirror images. Spacing and measurements should be followed as such.
 - Roof Lights on the left () and Right (South East) side columns of building are a mirror images. Spacing and measurements should be followed as such.
 - Front Facade Lights on the Left () and Right sides of the tower are a mirror images. Spacing and measurements should be followed as such.

- Key**
- ProPoint RGBW Wall Washer 40W
 - Allegro Linear AC 1200
 - SGM I-5
 - SGM G-Spot Turbo POI


No.	Date	Issue Notes


 Design Firm: **Kahkonen, Smith and Uncein**
 Project Title: **Hallgrimskirkja**
 Sheet Title: **Column Plan**
 Drawn By: **Ulfie Kahkonen, Thomas Uncein** Date: **12/15/20**
 CAD File Name: **Hallgrimskirkja Final Drafting Package.vwx**


3	of	9
---	----	---

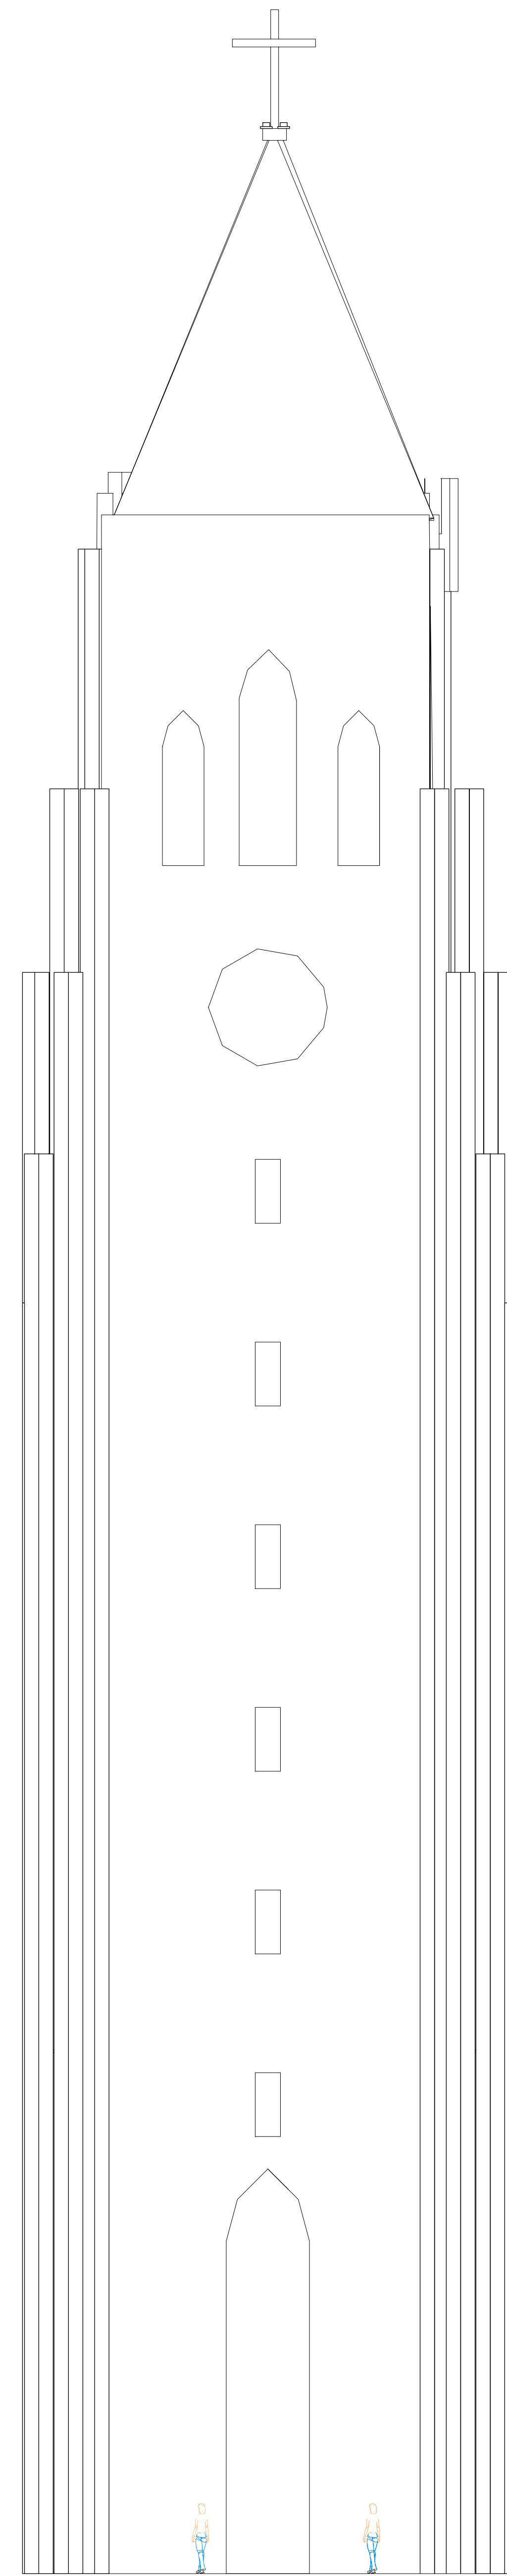

2 Tower Section
Scale: 1/8" = 1'-0"

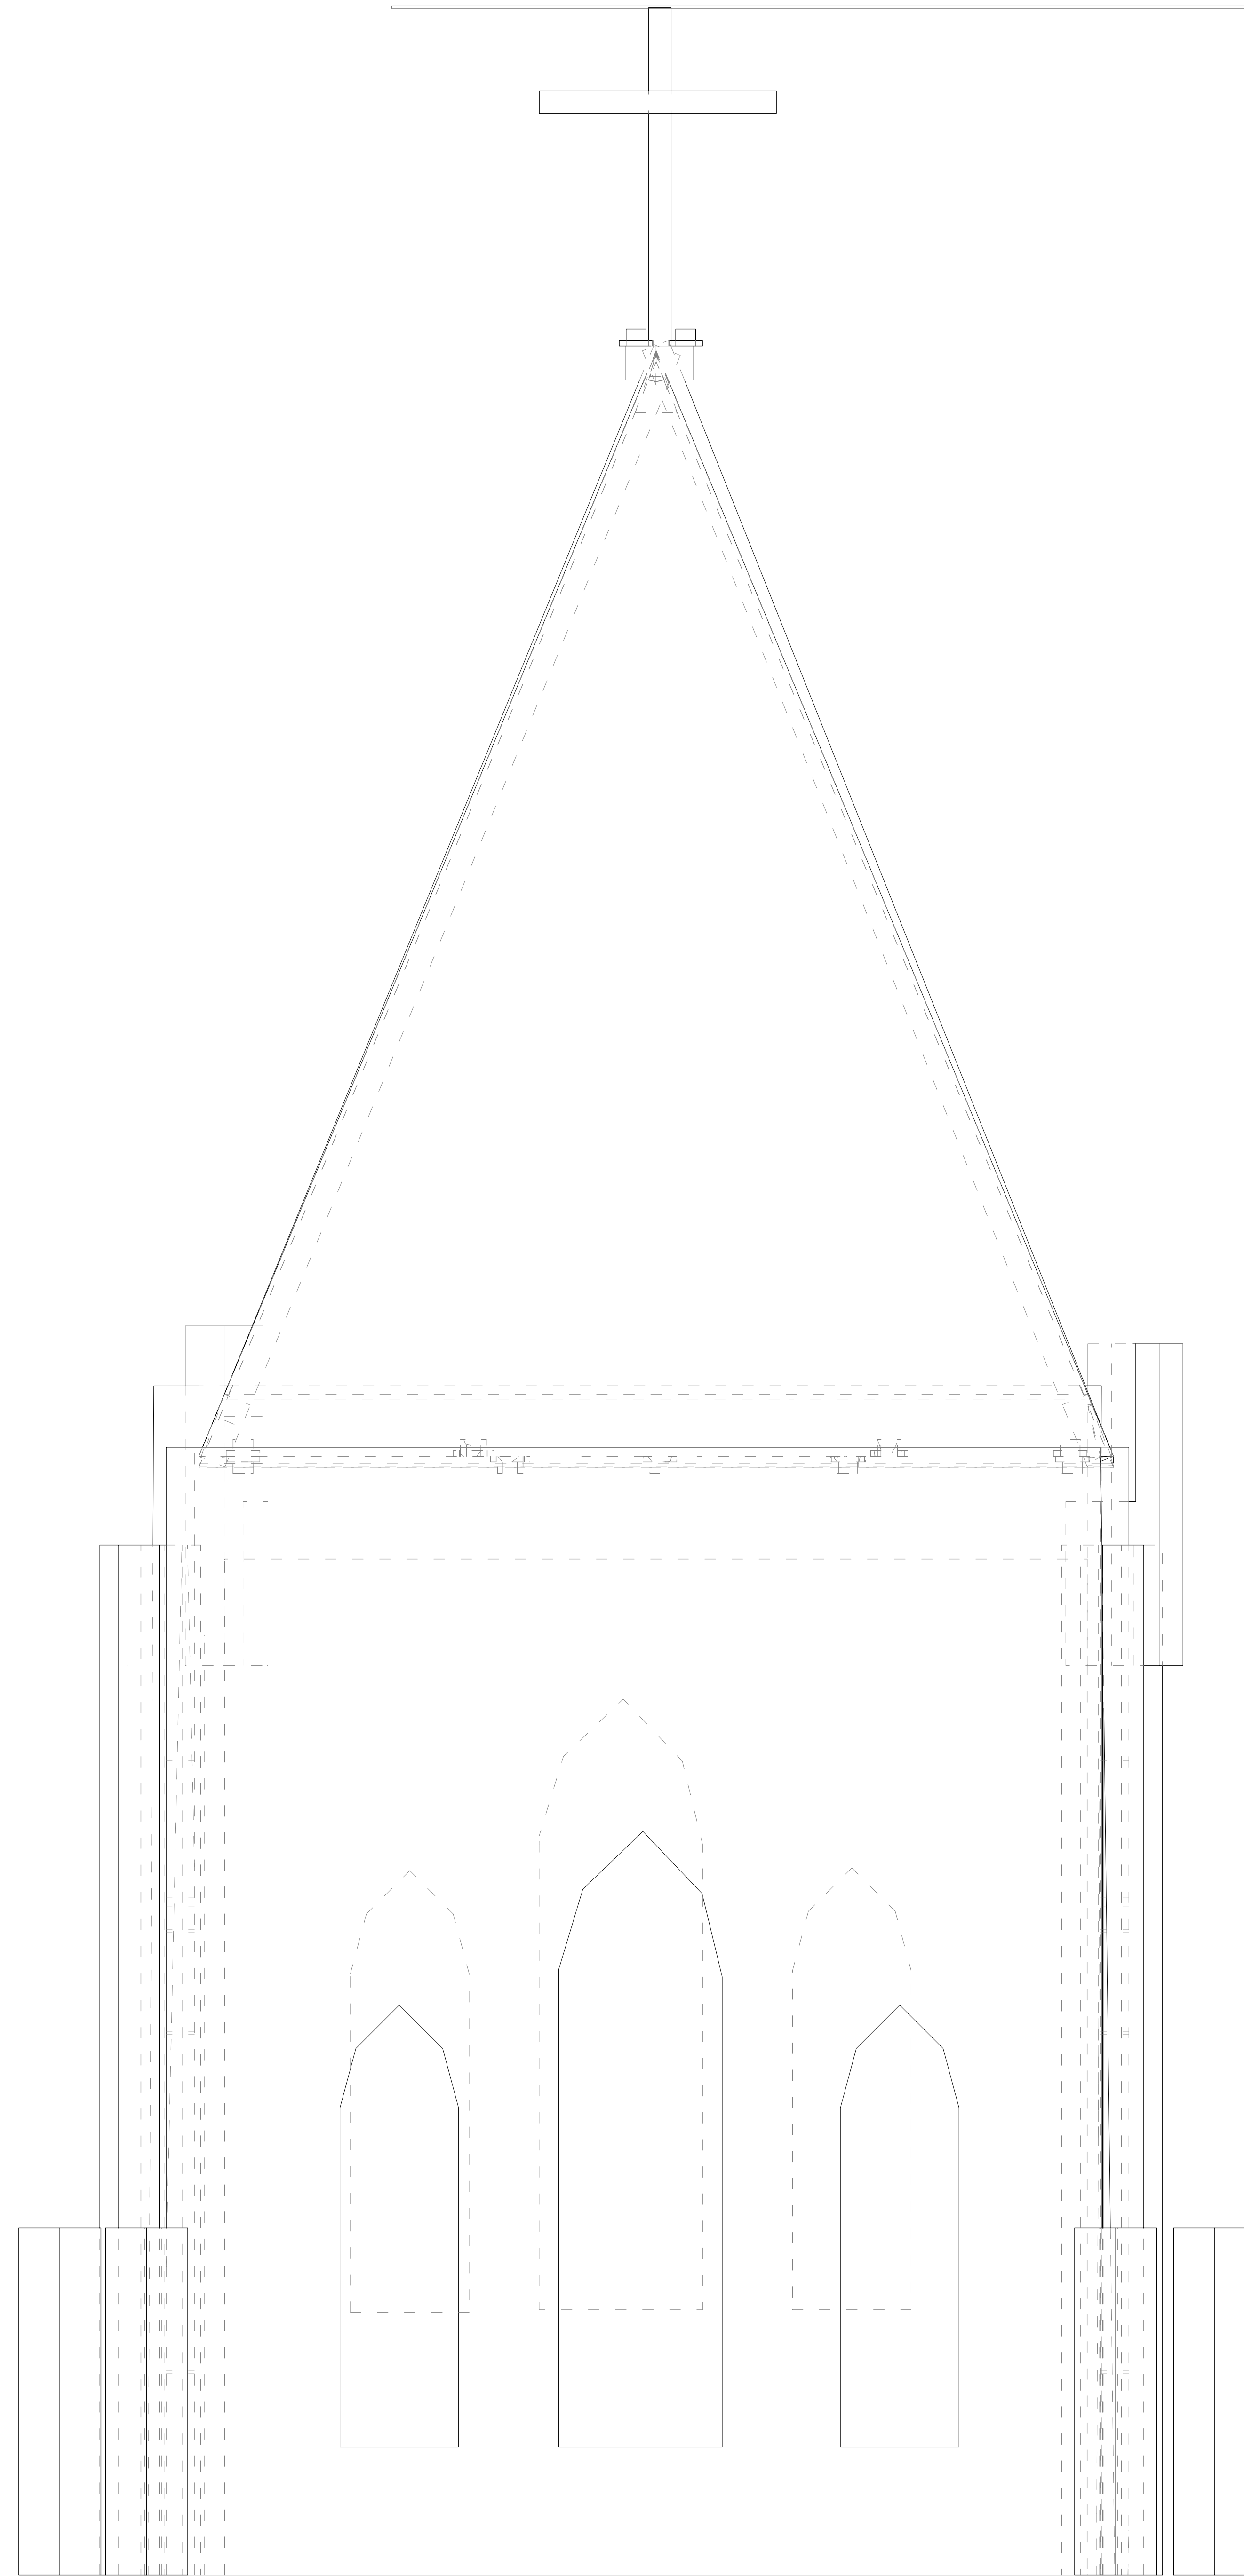

3 Tower Section - Closeup
Scale: 3/8" = 1'-0"

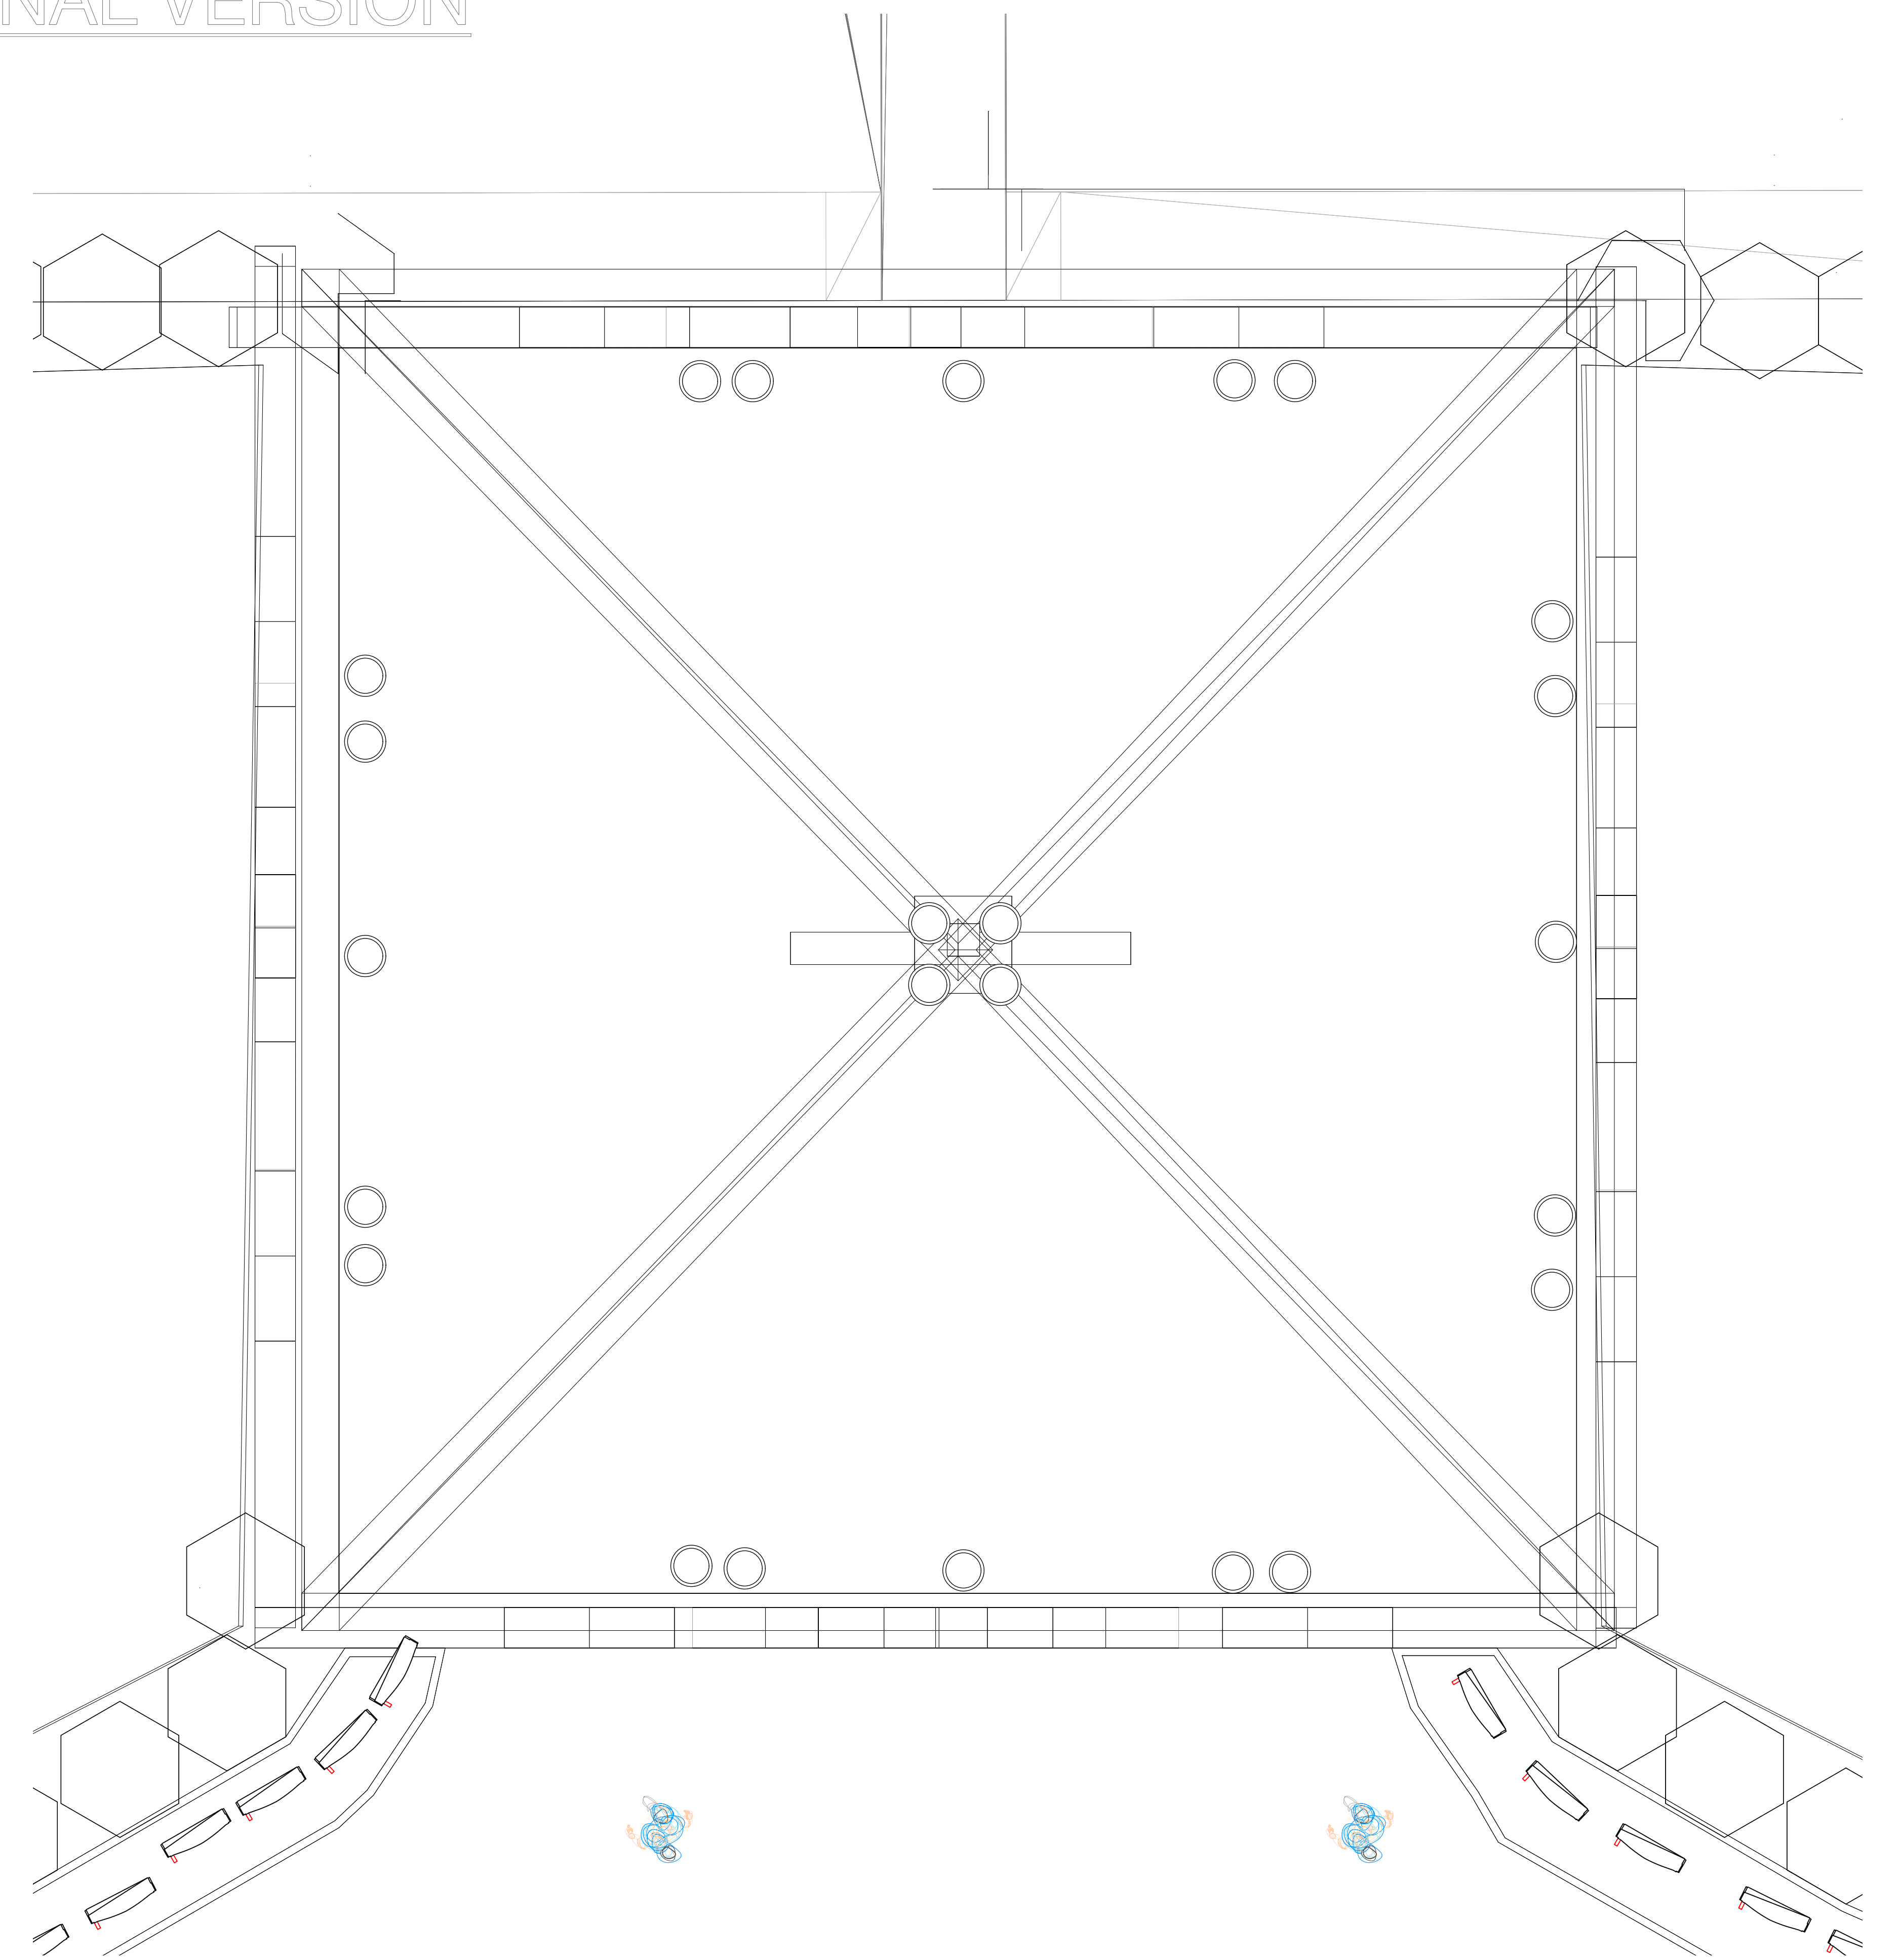

1 Tower Plan
Scale: 1/2" = 1'-0"

Key

- ProPoint RGBW Wall Washer 40W
- Allegro Linear AC 1200
- SGM I-5
- SGM G-Spot Turbo POI



No.	Date	Issue Notes

Design Firm: **Kahkonen, Smith and Uncein**

Project Title: **Hallgrimskirkja**

Sheet Title: **Tower Plan & Section**

Drawn By: Lilja Kahkonen, Thomas Uncein	Size: Assorted
Date: 12/18/20	4 of 9
CAD File Name: Hallgrimskirkja Final Drafting Package.vwx	

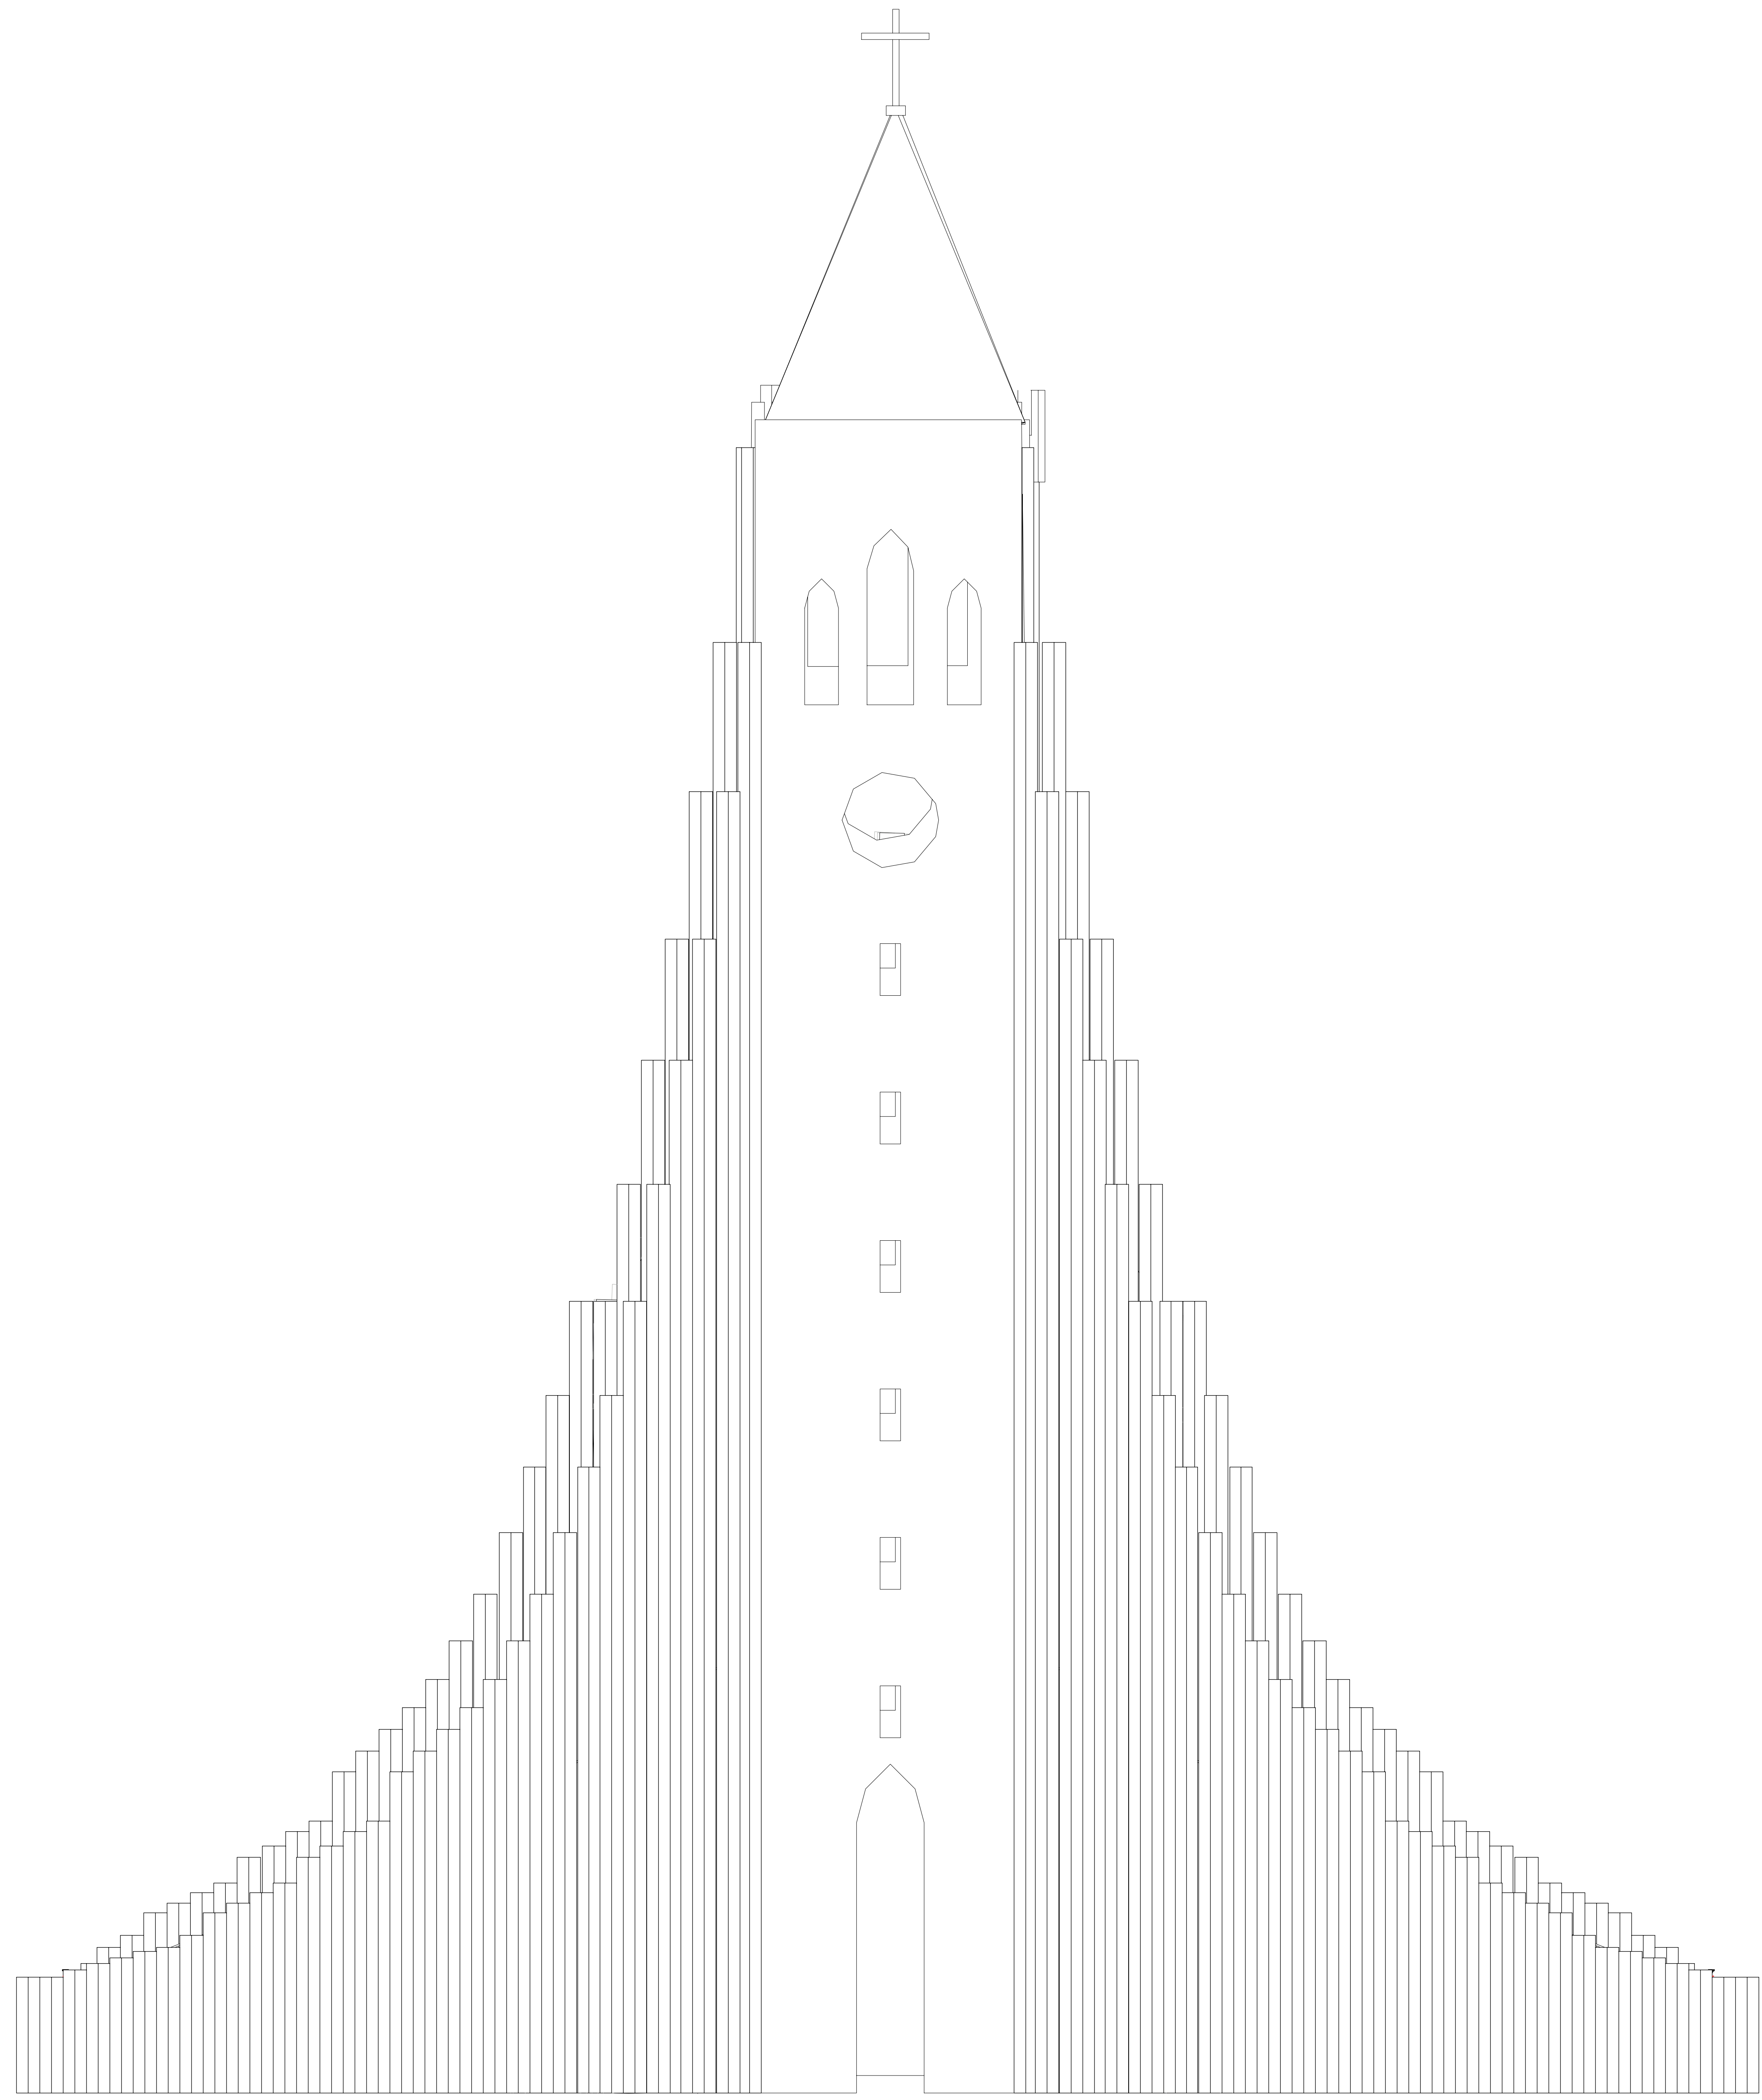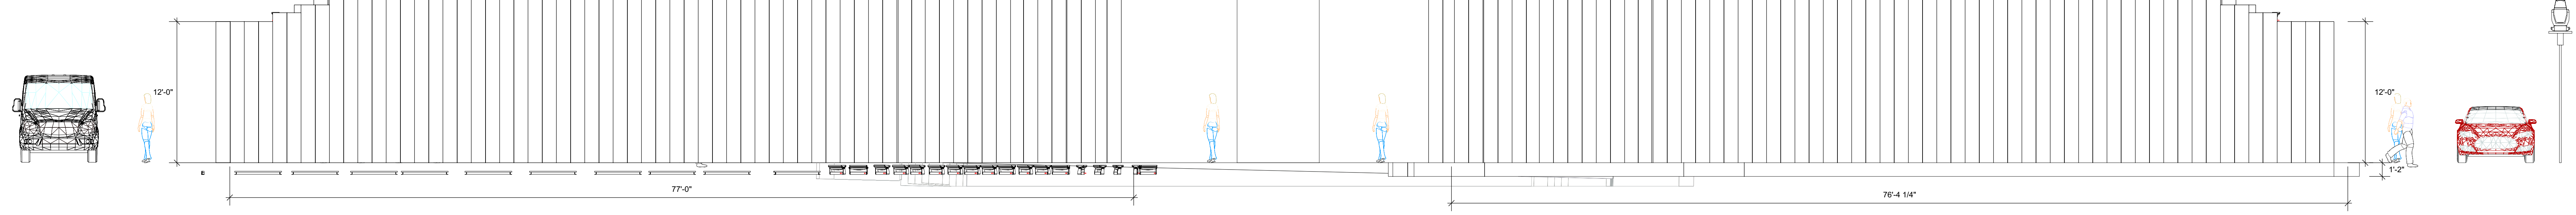

Key

- ProPoint RGBW Wall Washer 40W
- Allegro Linear AC 1200
- SGM I-5
- SGM G-Spot Turbo POI

No.	Date	Issue Notes


Design Firm: **Kahkonen, Smith and Uncein**

Project Title: **Hallgrimskirkja**


Sheet Title: **Front Section**

Drawn By: Lilje Kahkonen, Thomas Uncein	Size: Assorted
Date: 12/15/20	5 of 9
CAD File Name: Hallgrimskirkja Final Drafting Package.vwx	


1 Left Section
Scale: 1/8" = 1'-0"

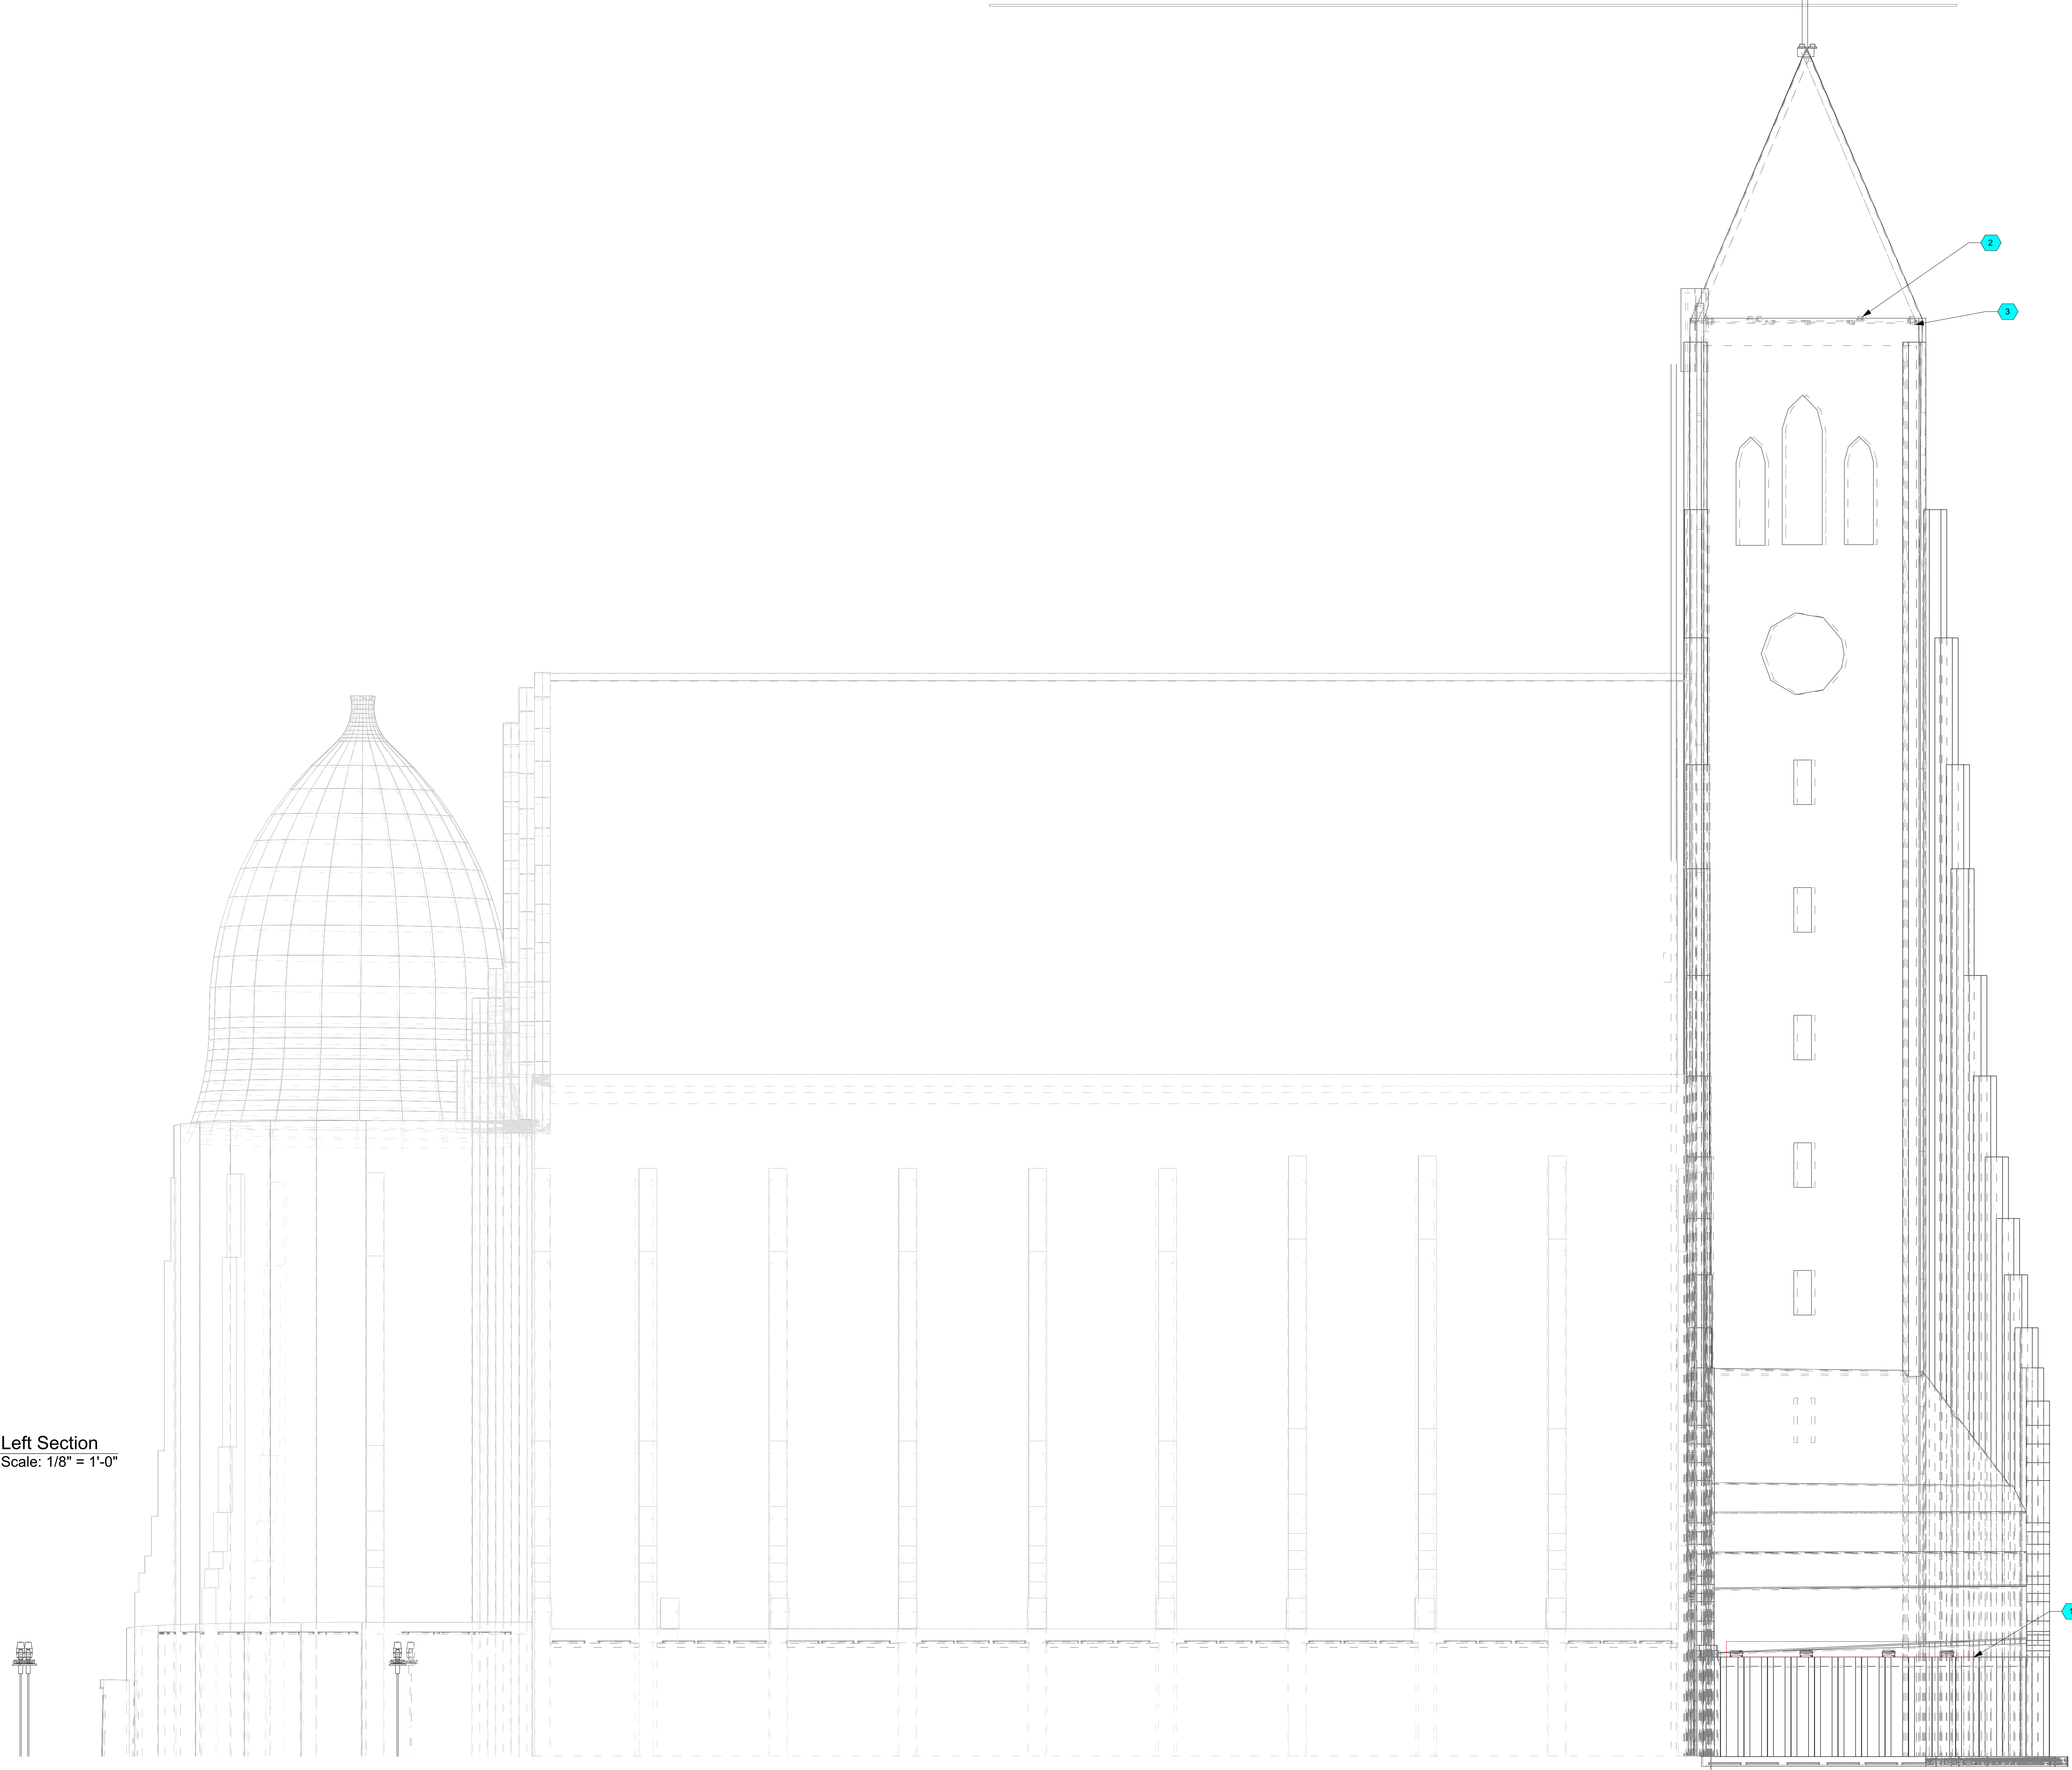

4 Right Section
Scale: 1/4" = 1'-0"

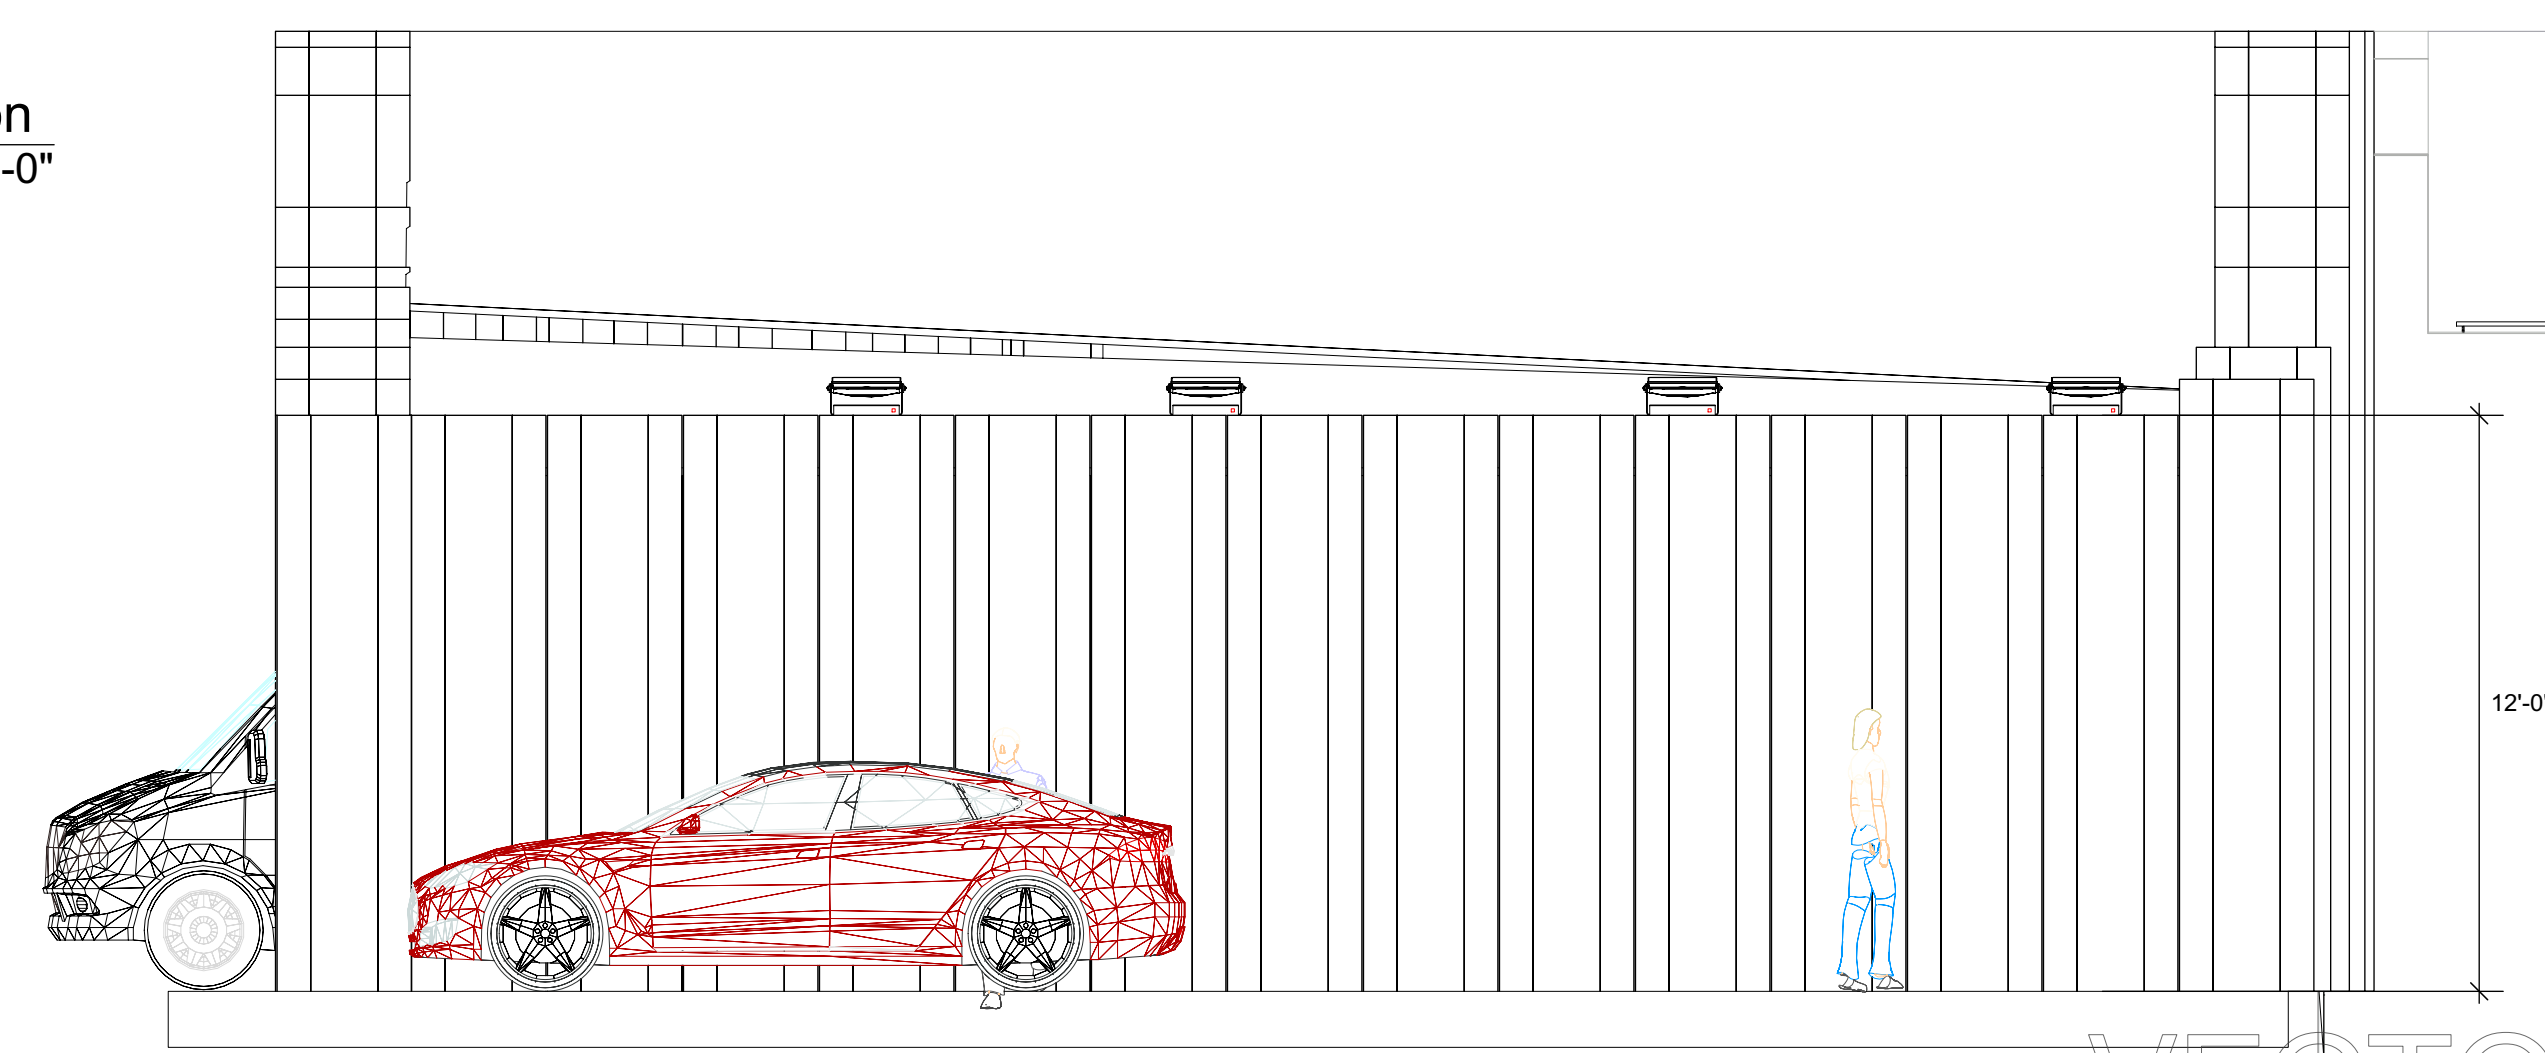

3 Left Section
Scale: 1/4" = 1'-0"

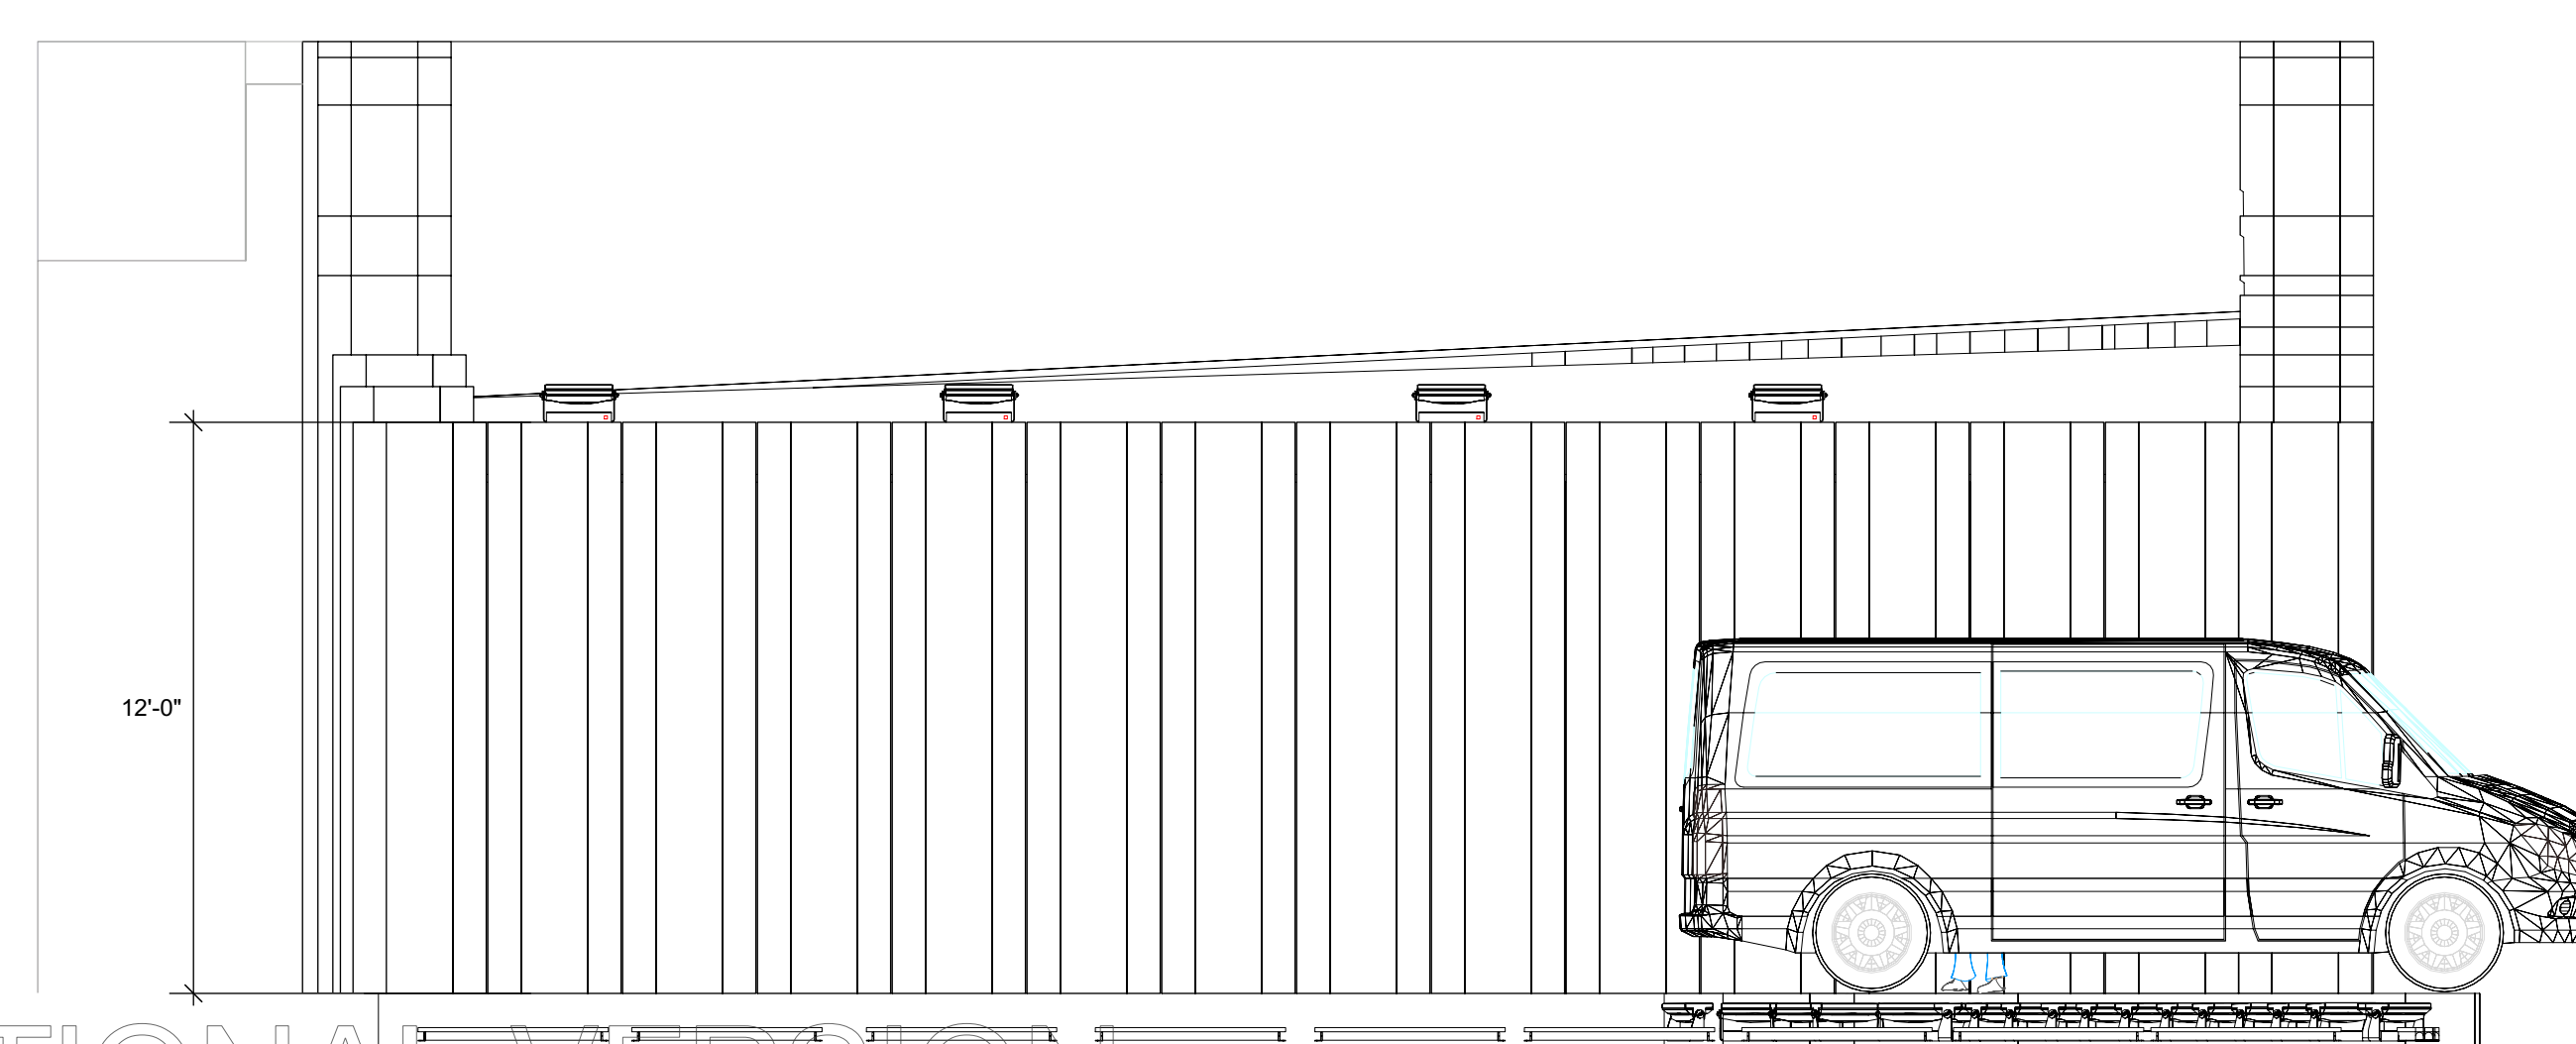

Notes

- 1 - I-5 Lighting the Tower Facade
- 2 - Propoints lighting holes in roof
- 3 - Propoints Lighting Large Windows

Key

- ProPoint RGBW Wall Washer 40W
- Allegro Linear AC 1200
- SGM I-5
- SGM G-Spot Turbo POI

No.	Date	Issue Notes







Design Firm: Kahkonen, Smith and Uncein

Project Title: Hallgrimskirkja

Sheet Title: Side Section

Drawn By: Ulisse Kahkonen, Thomas Uncein
Date: 12/15/20

CAD File Name: Hallgrimskirkja Final Drafting Package.vwx
6 of 9

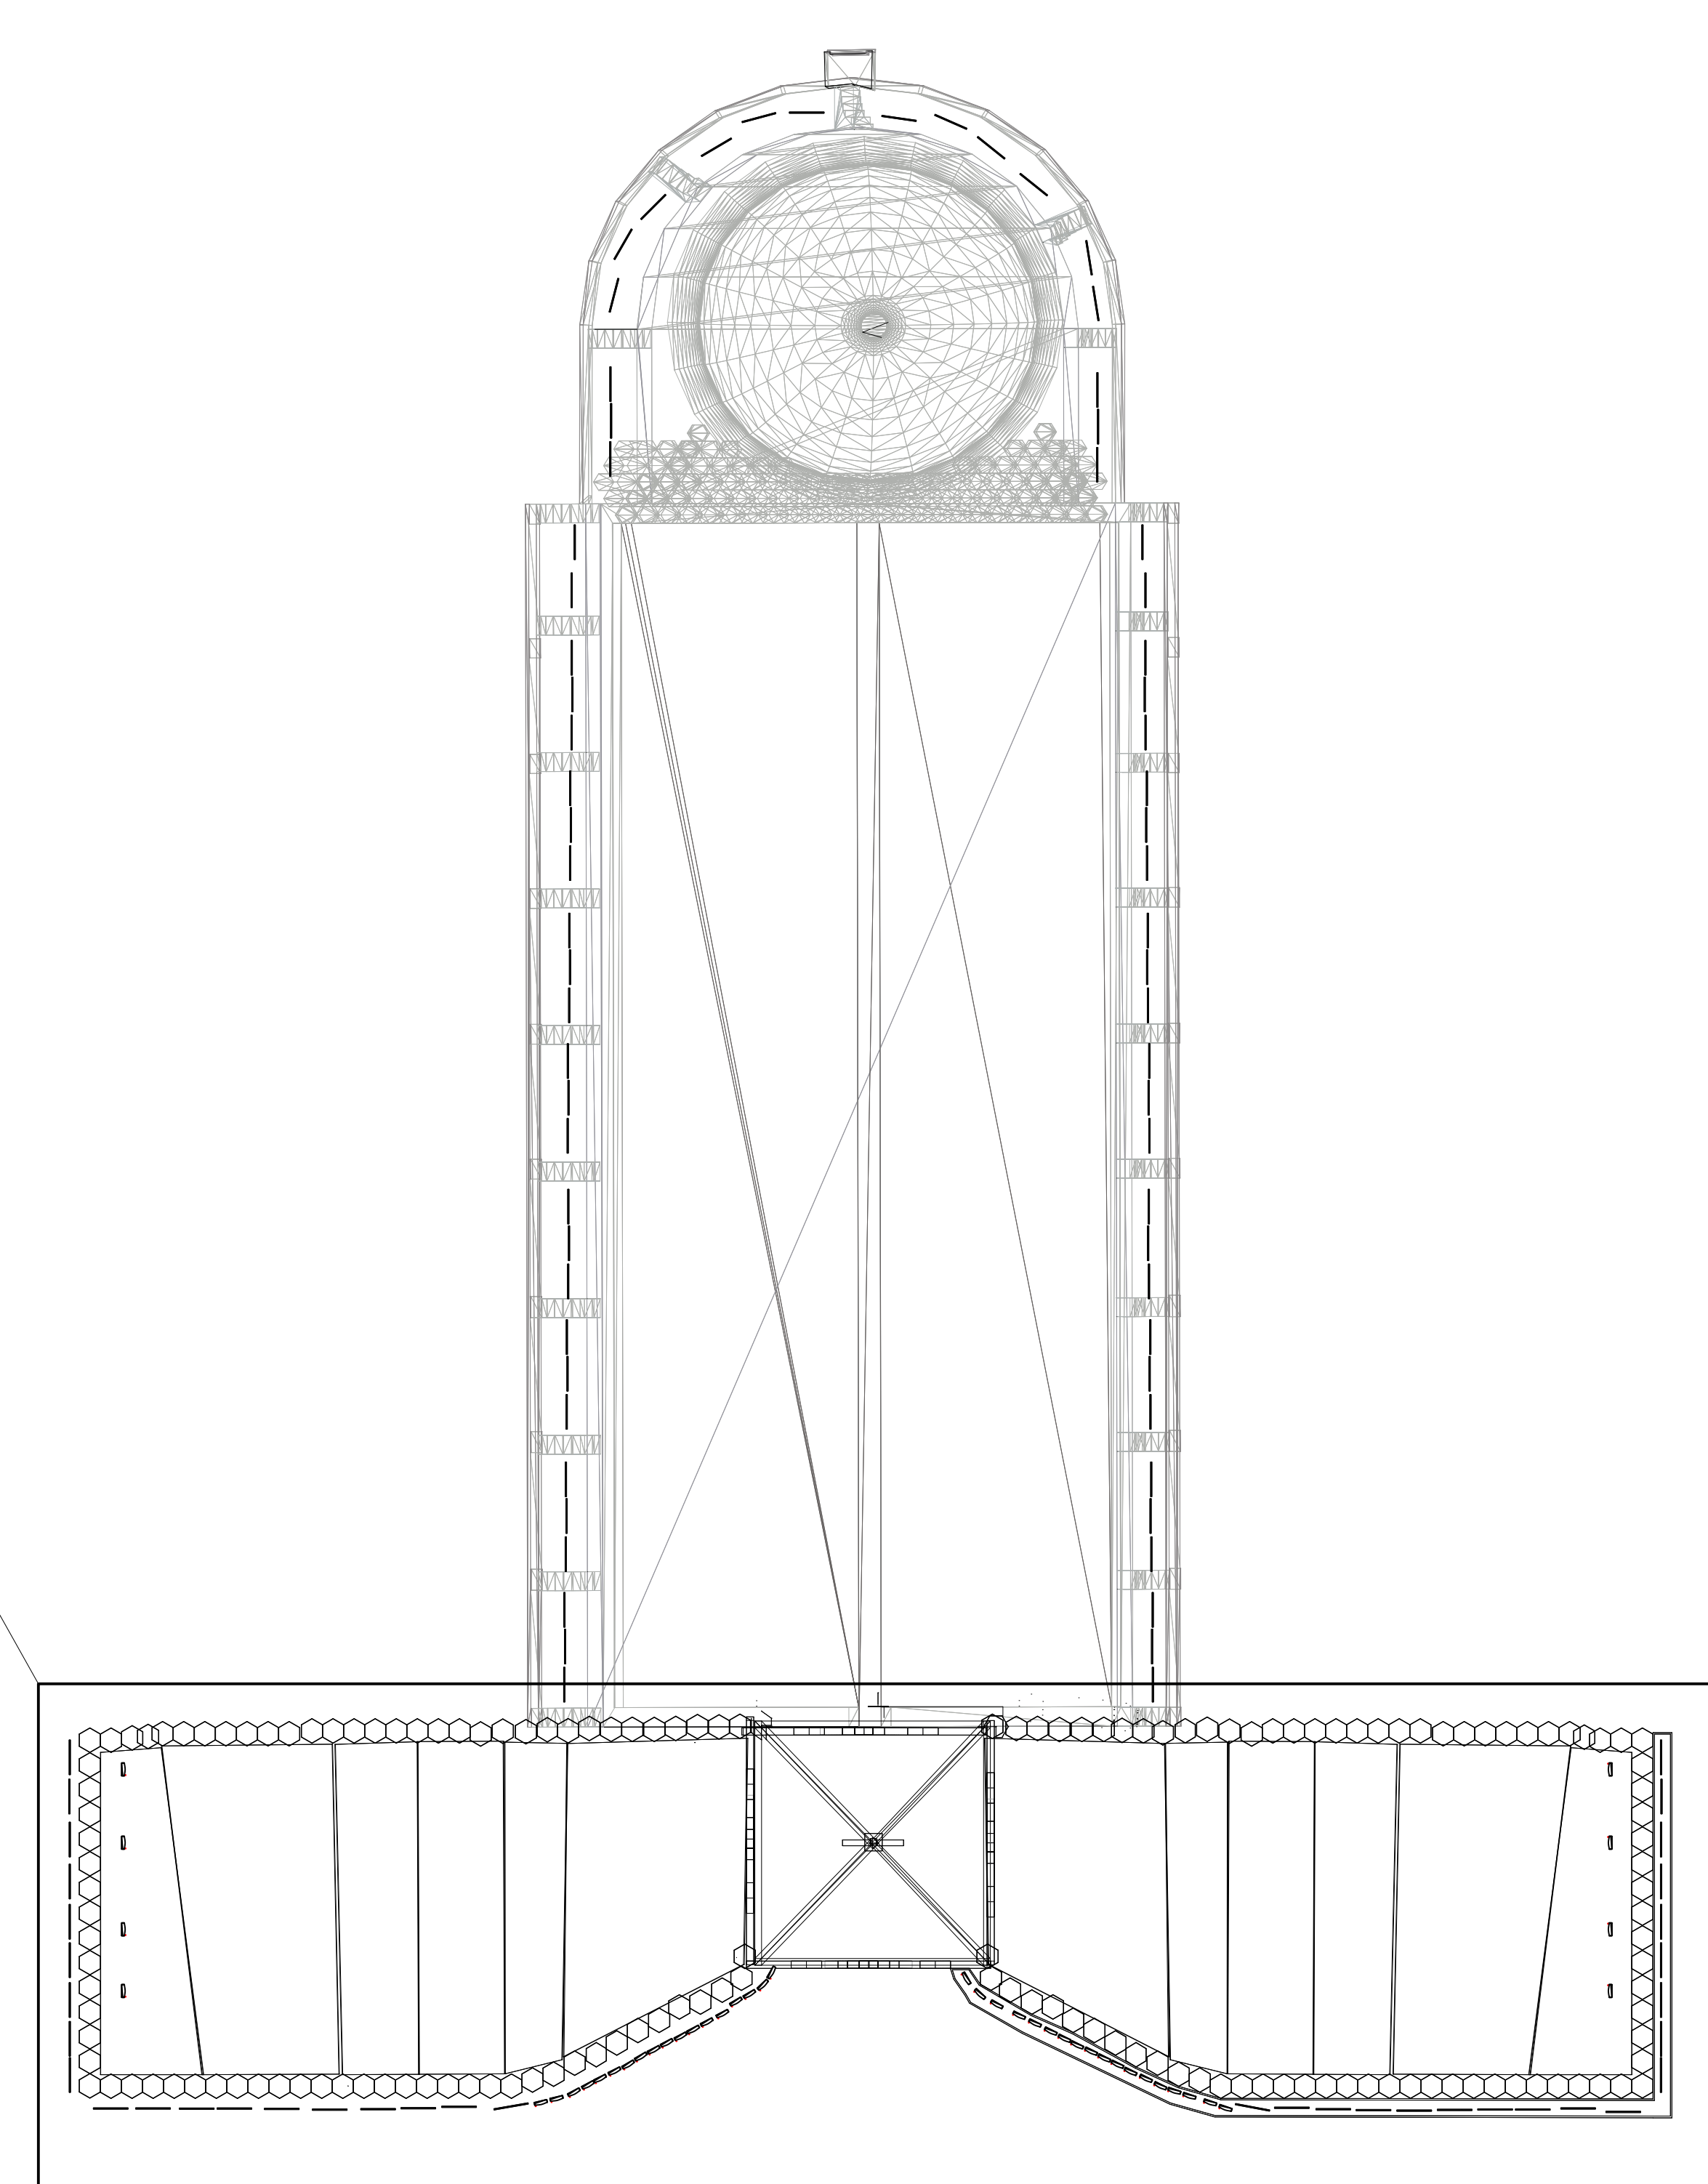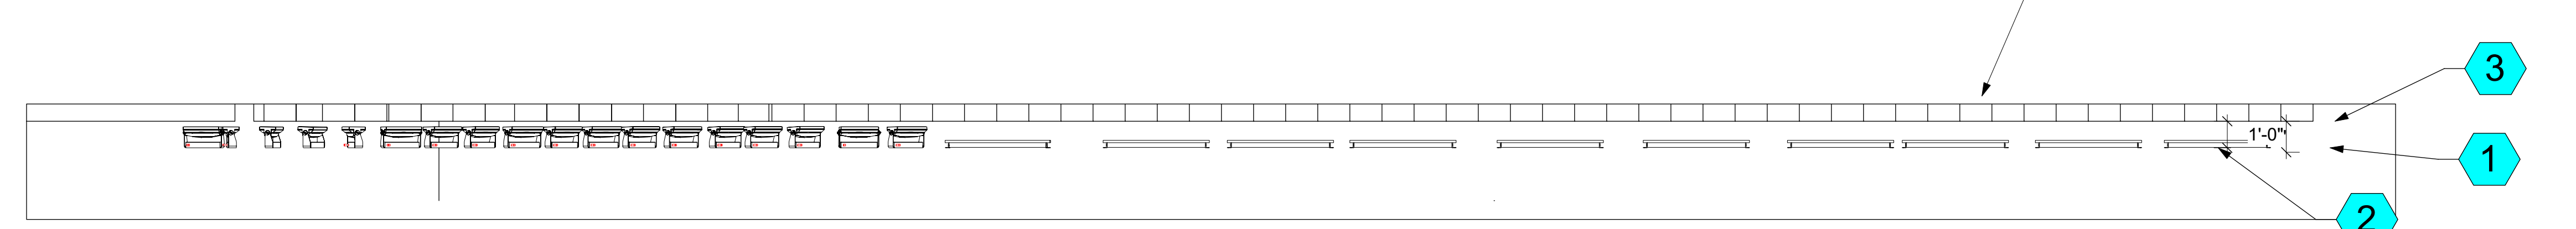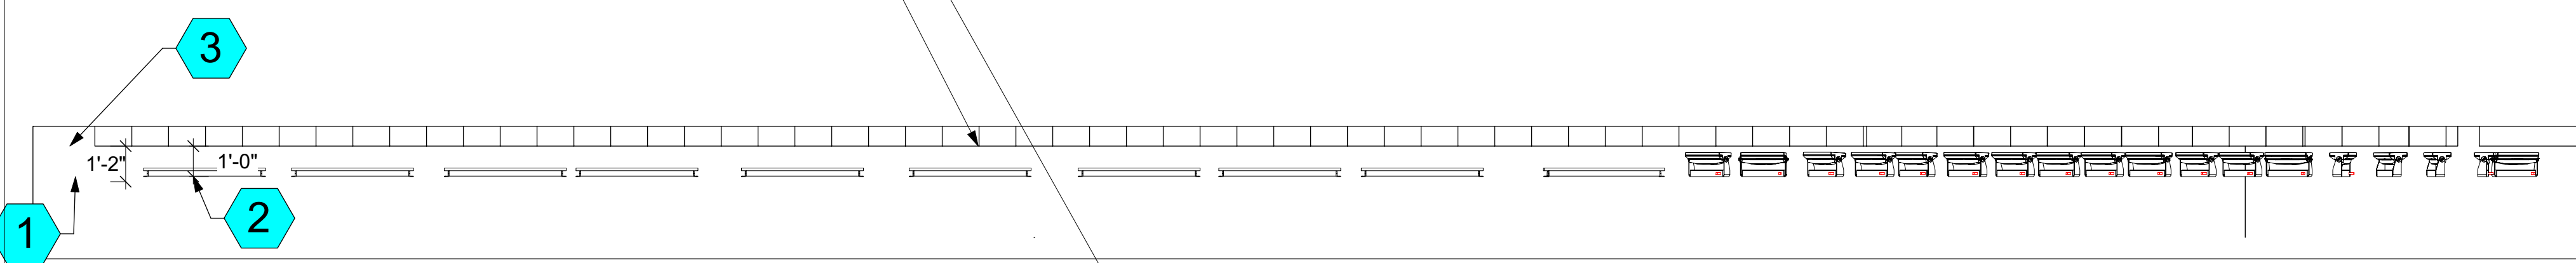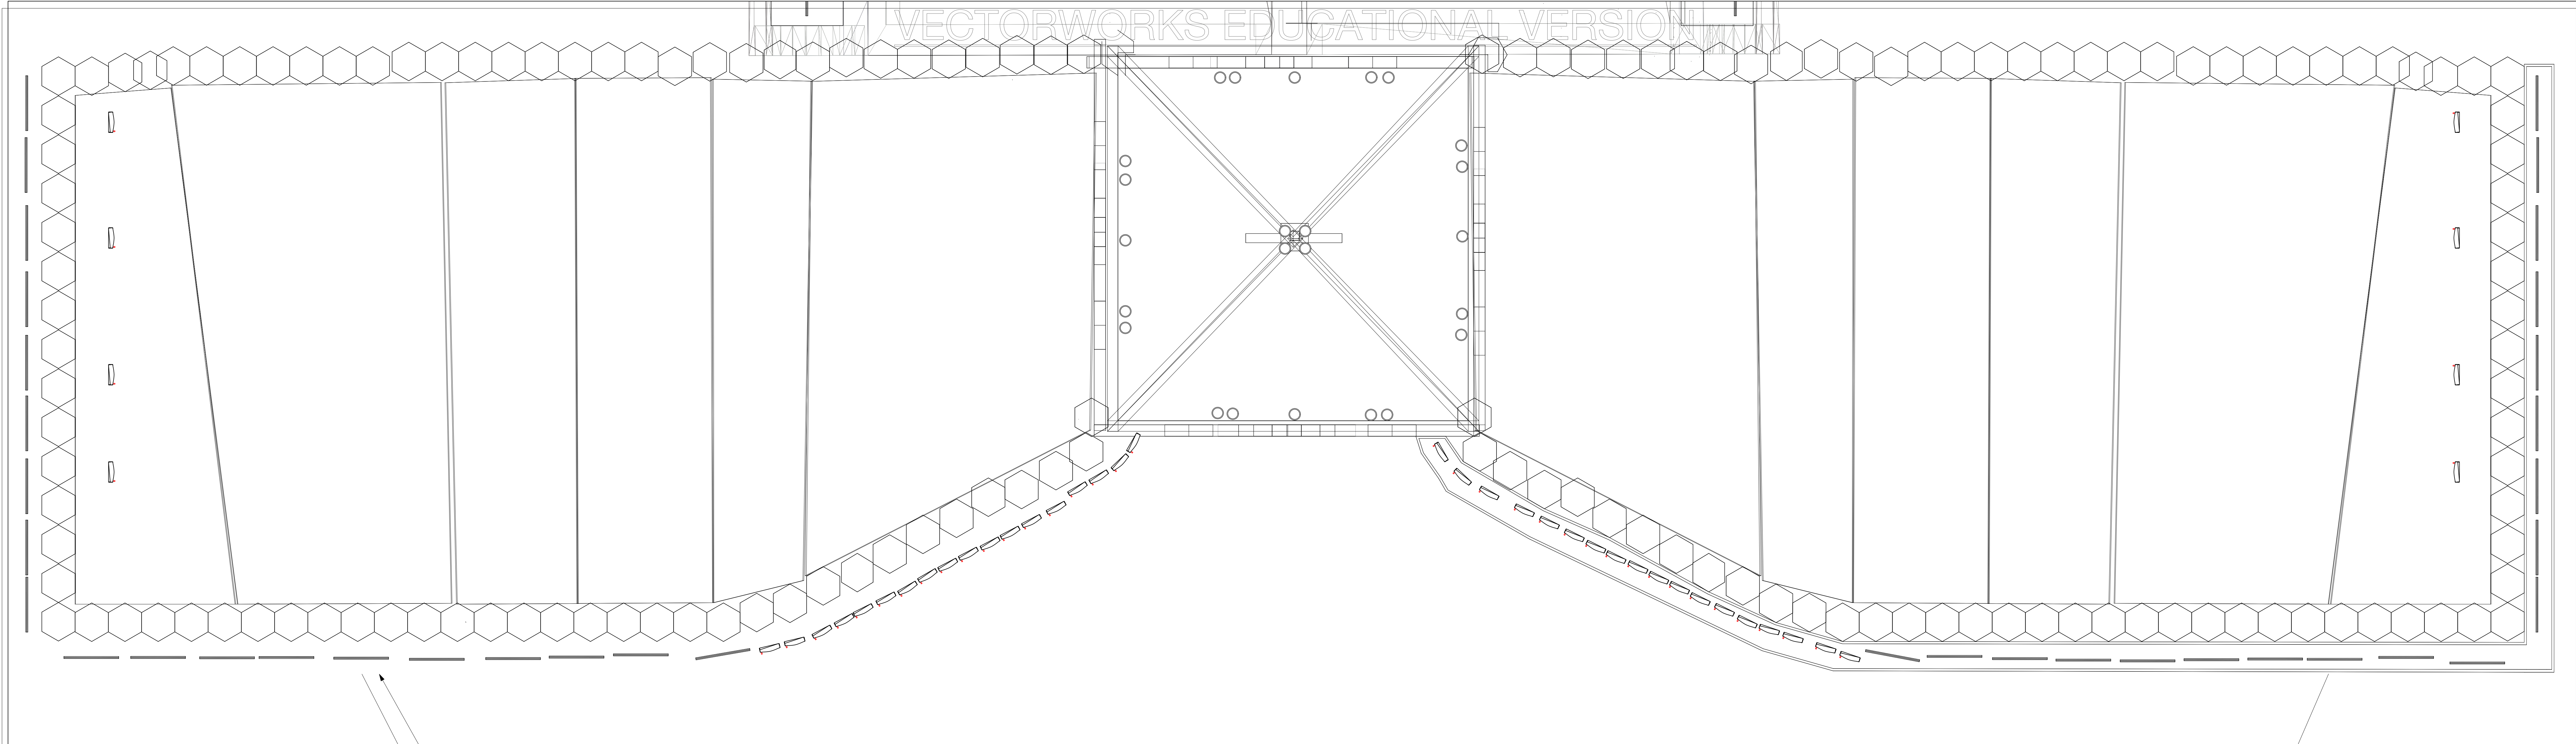


- Notes**
- 1. Depth of Trough including base
 - 2. Depth of Trough interior
 - 3. Trough measurement from the base of the church

- Key**
- - ProPoint RGBW Wall Washer 40W
 - - Allegro Linear AC 1200
 - - SGM I-5
 - - SGM G-Spot Turbo POI


No.	Date	Issue Notes




Design Firm: Kahkonen, Smith and Uncein	
Project Title: Hallgrimskirkja	
Sheet Title: Detail Section of Trough	
Drawn By: Lillie Kahkonen, Thomas Uncein	Size: Assorted
Date: 12/15/20	7 of 9
CAD File Name: Hallgrimskirkja Final Drafting Package.vwx	

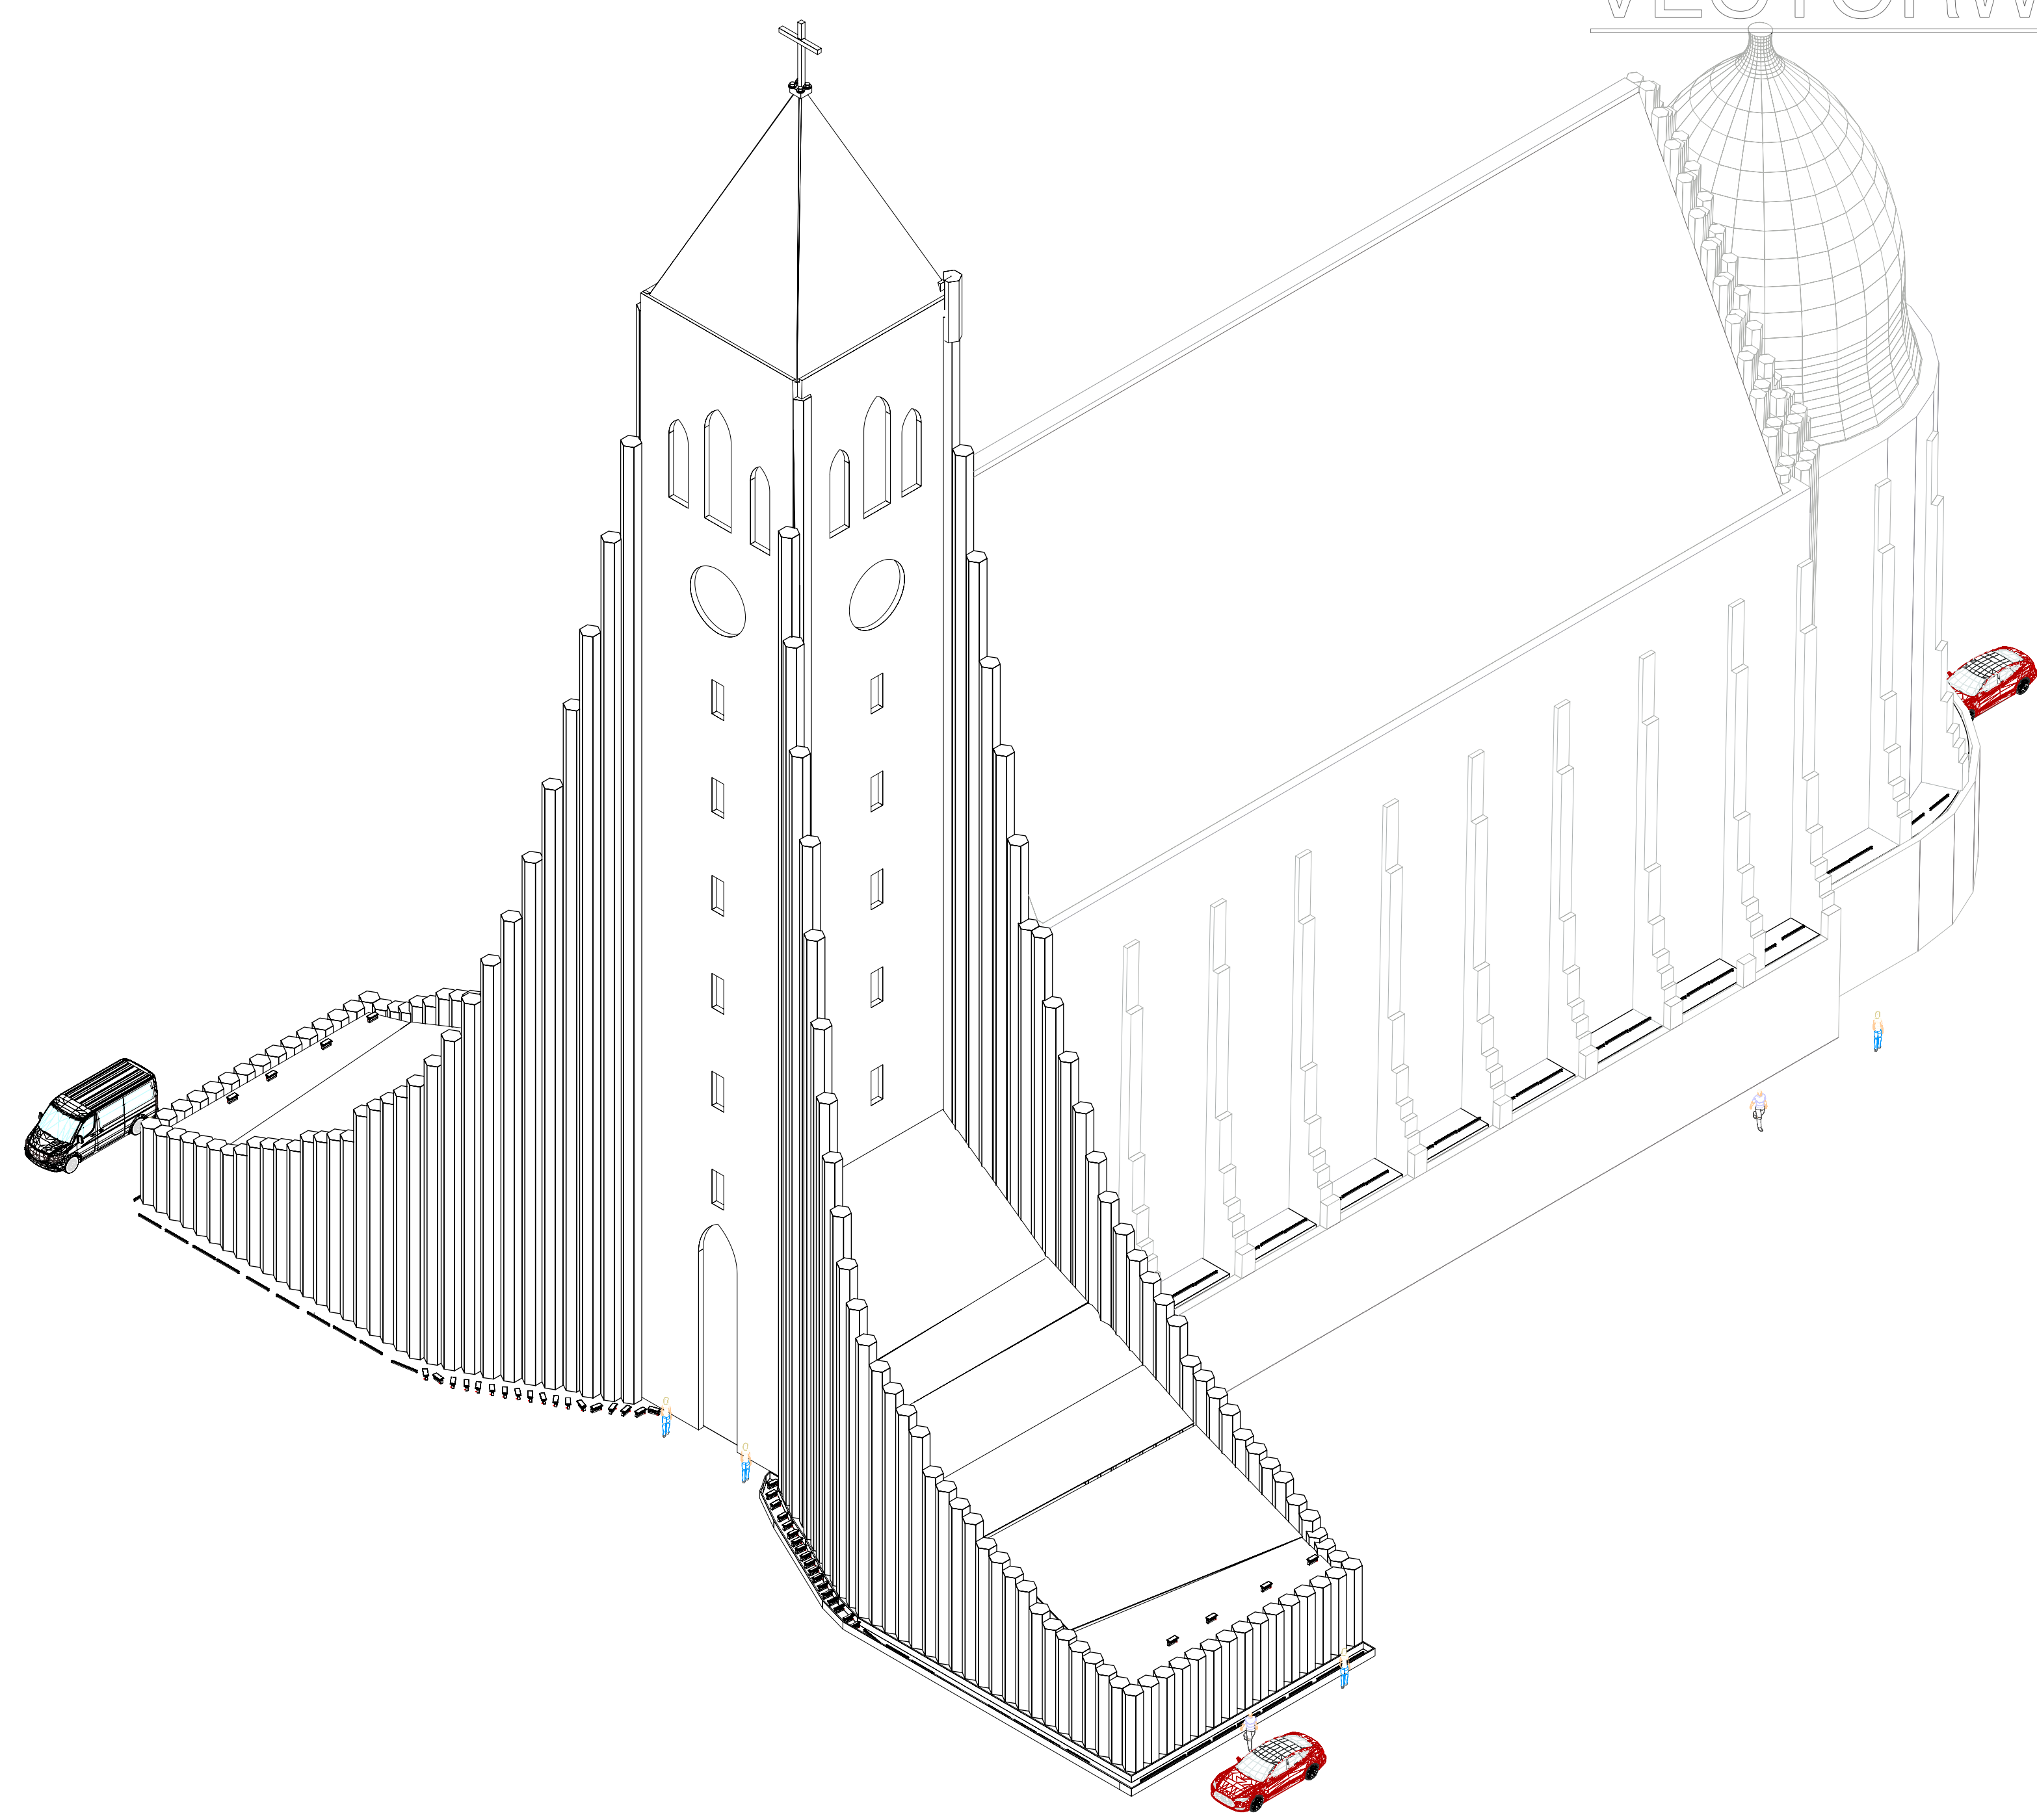


1 Right Isometric
Scale: 1/16" = 1'-0"

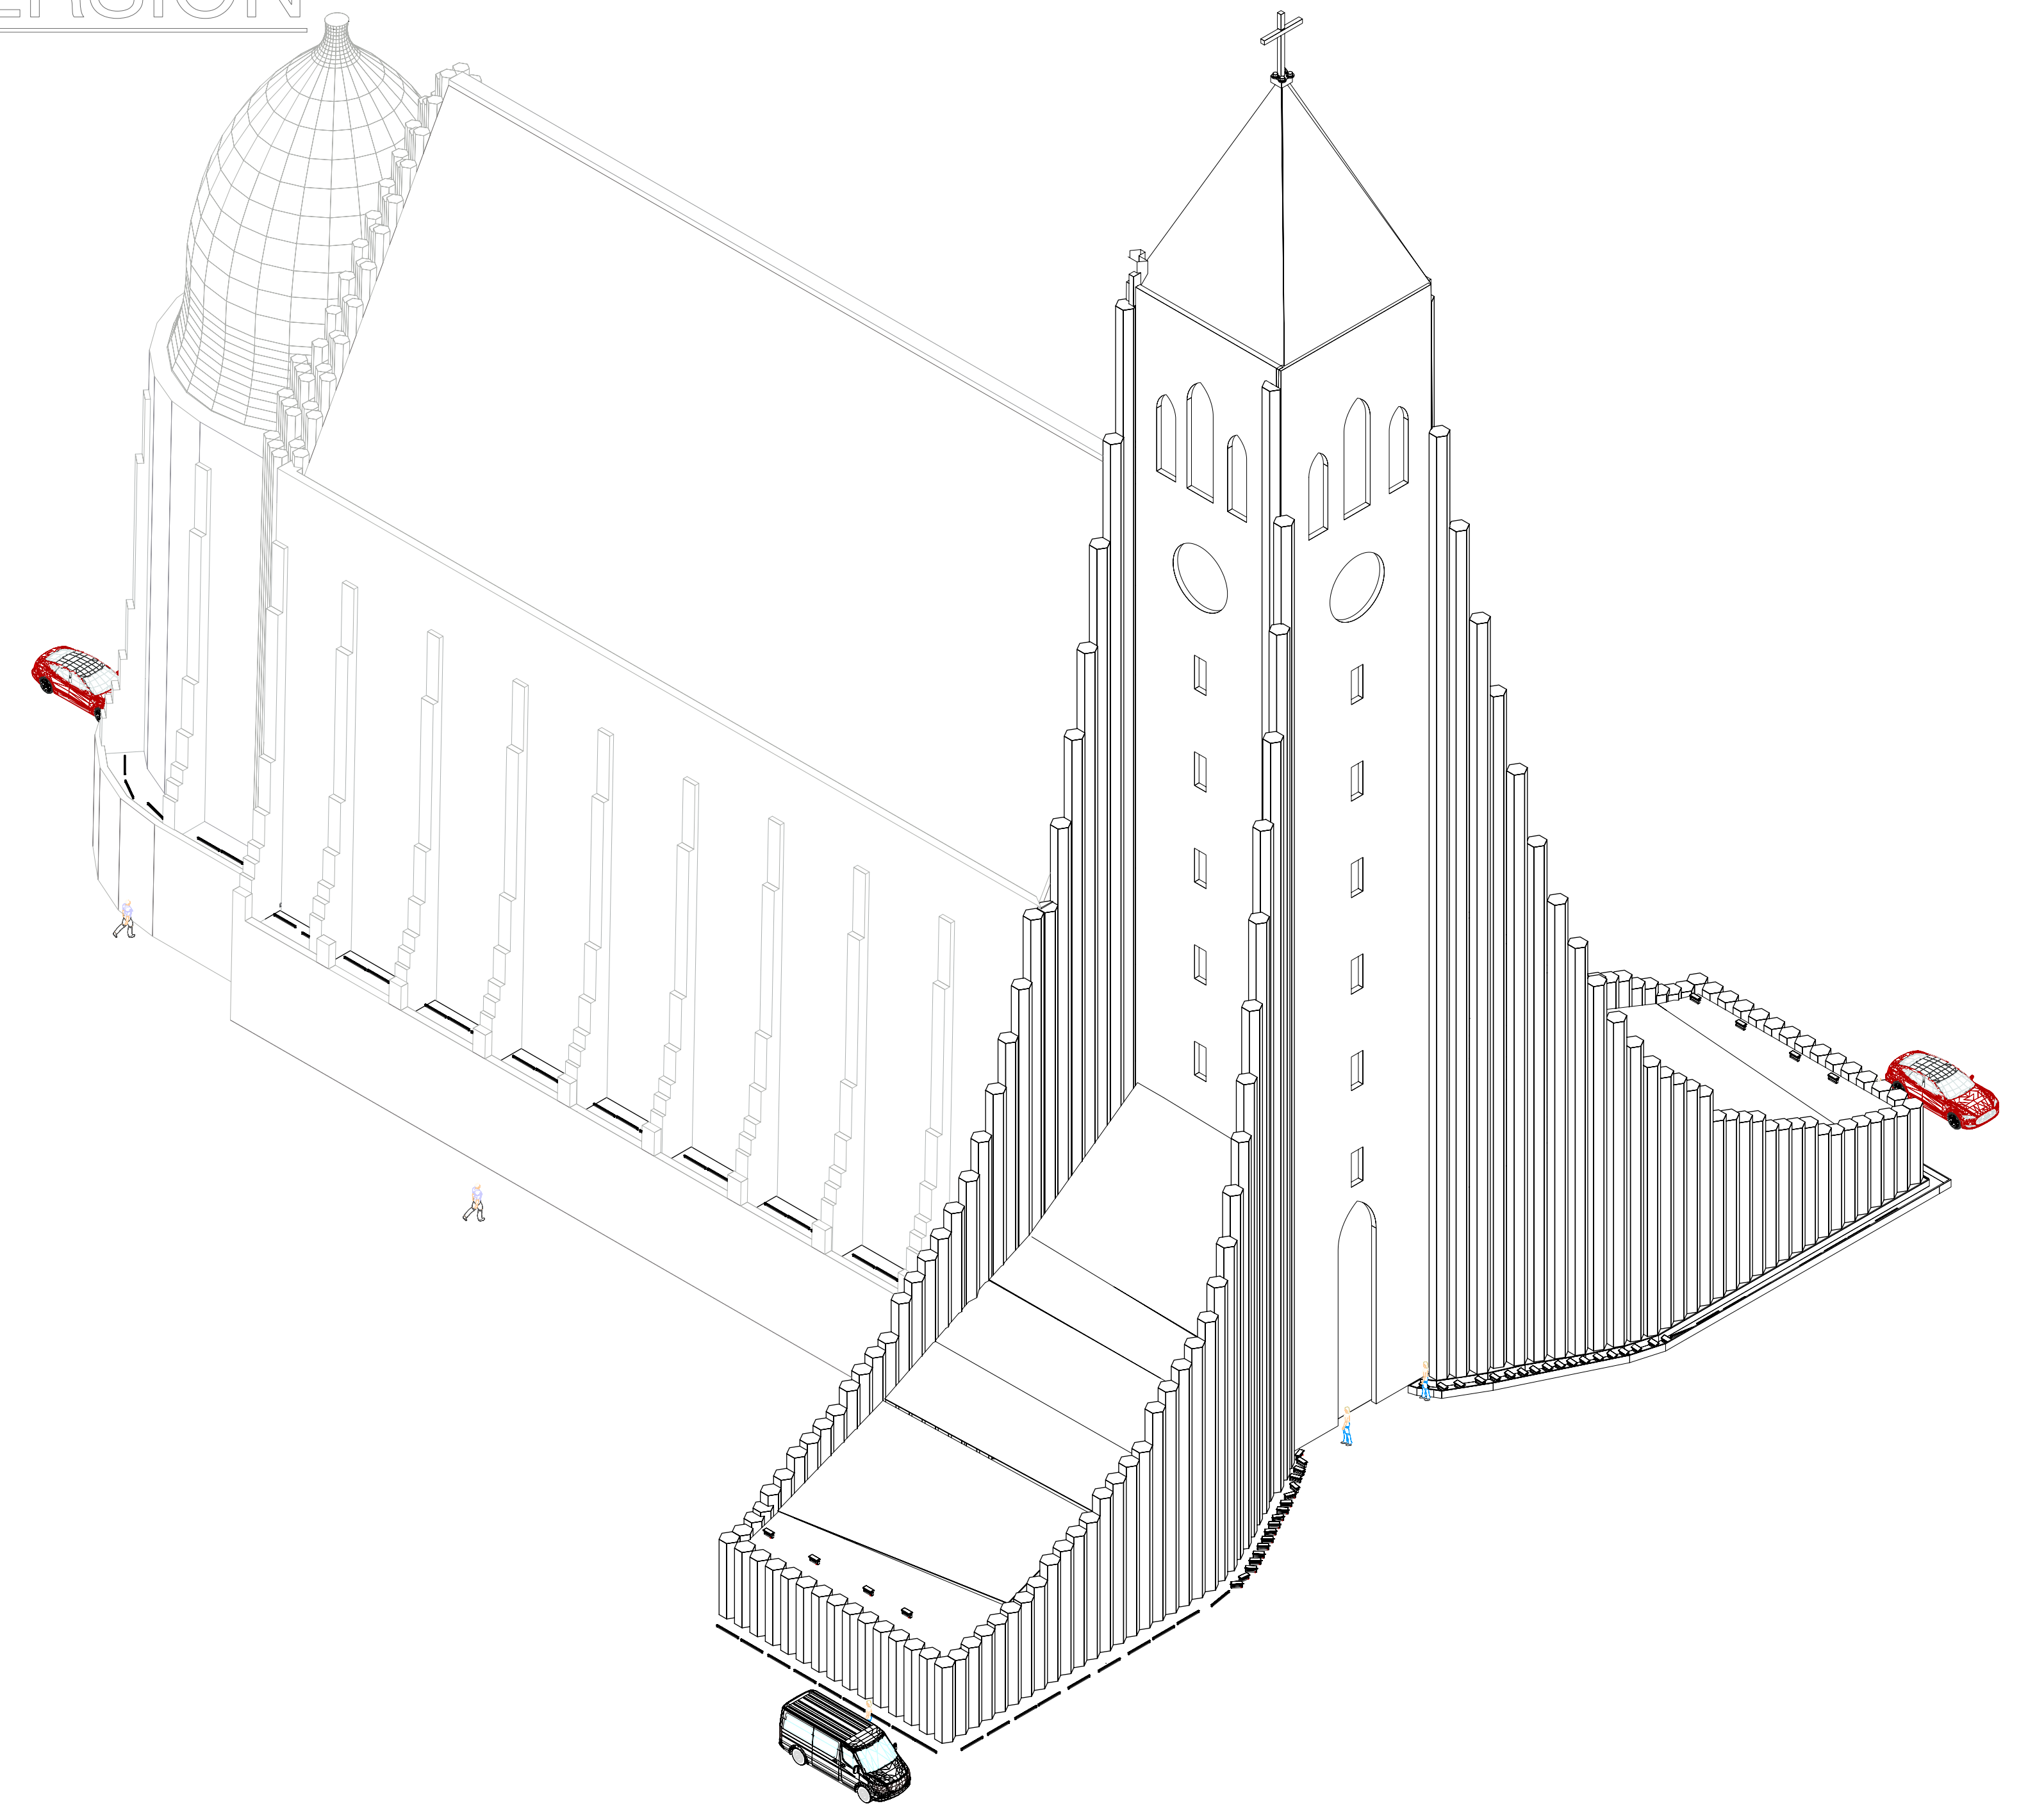

2 Left Isometric
Scale: 1/16" = 1'-0"

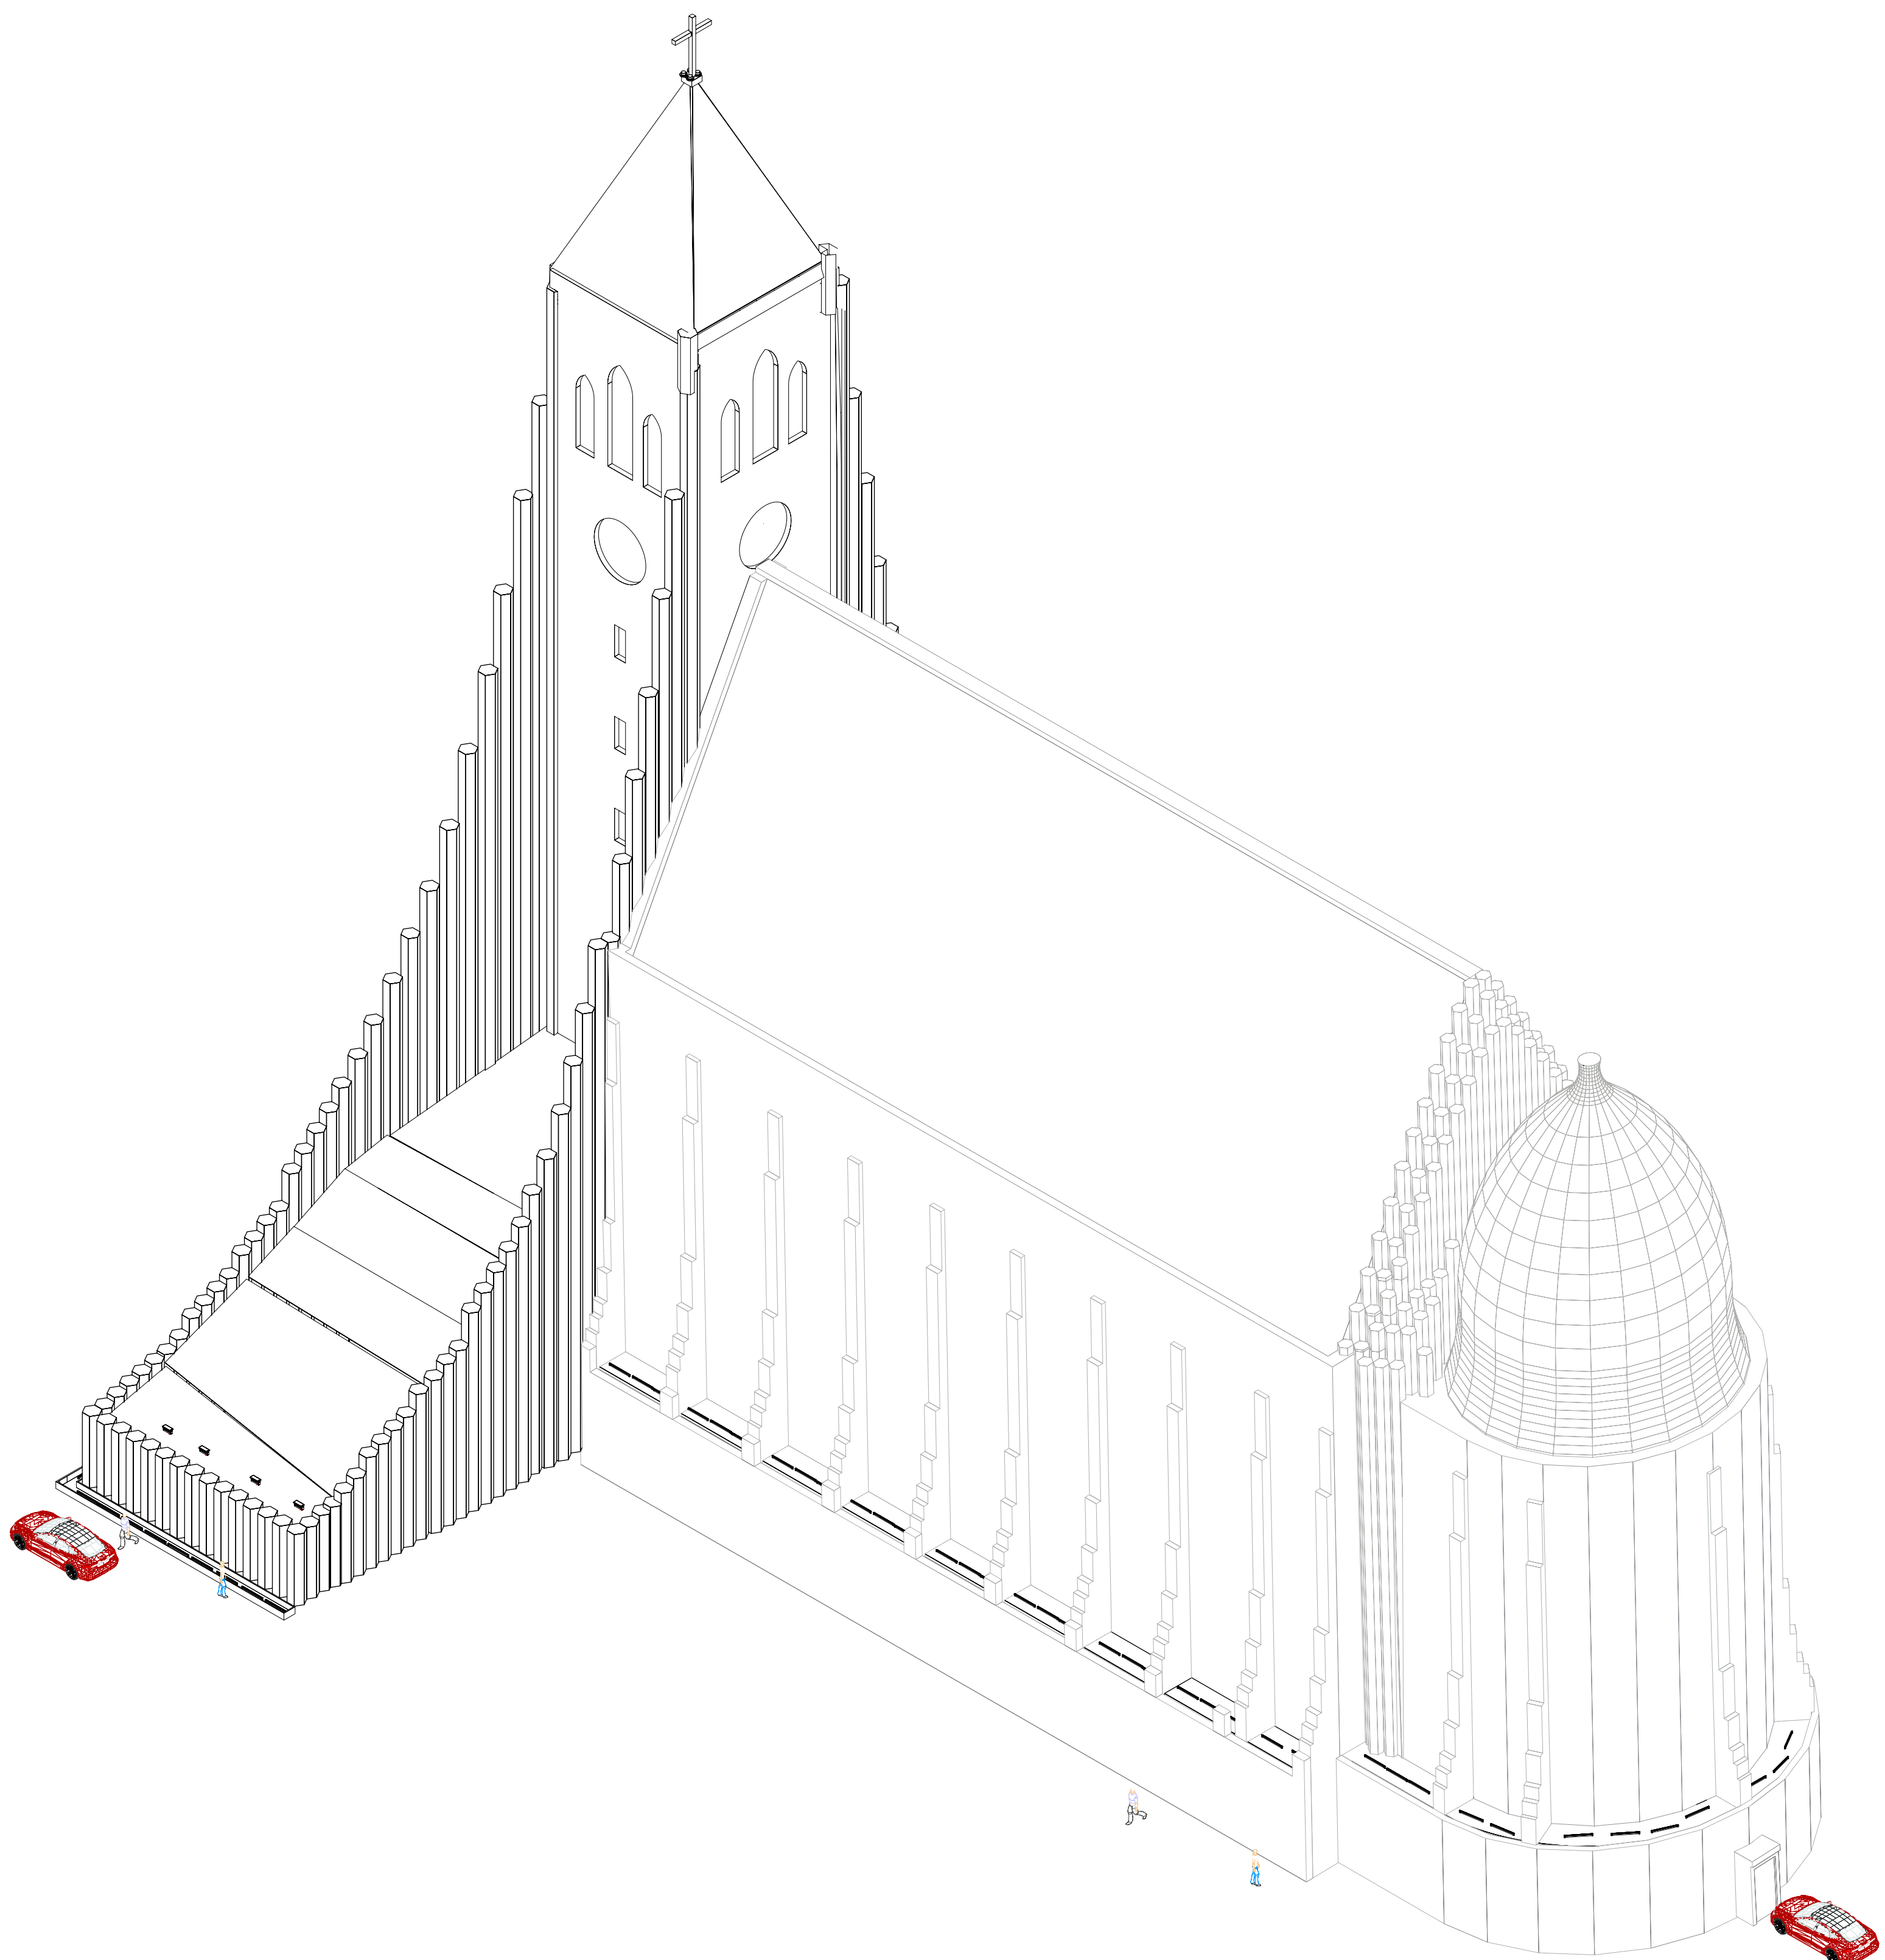

3 Right Rear Isometric
Scale: 1/16" = 1'-0"

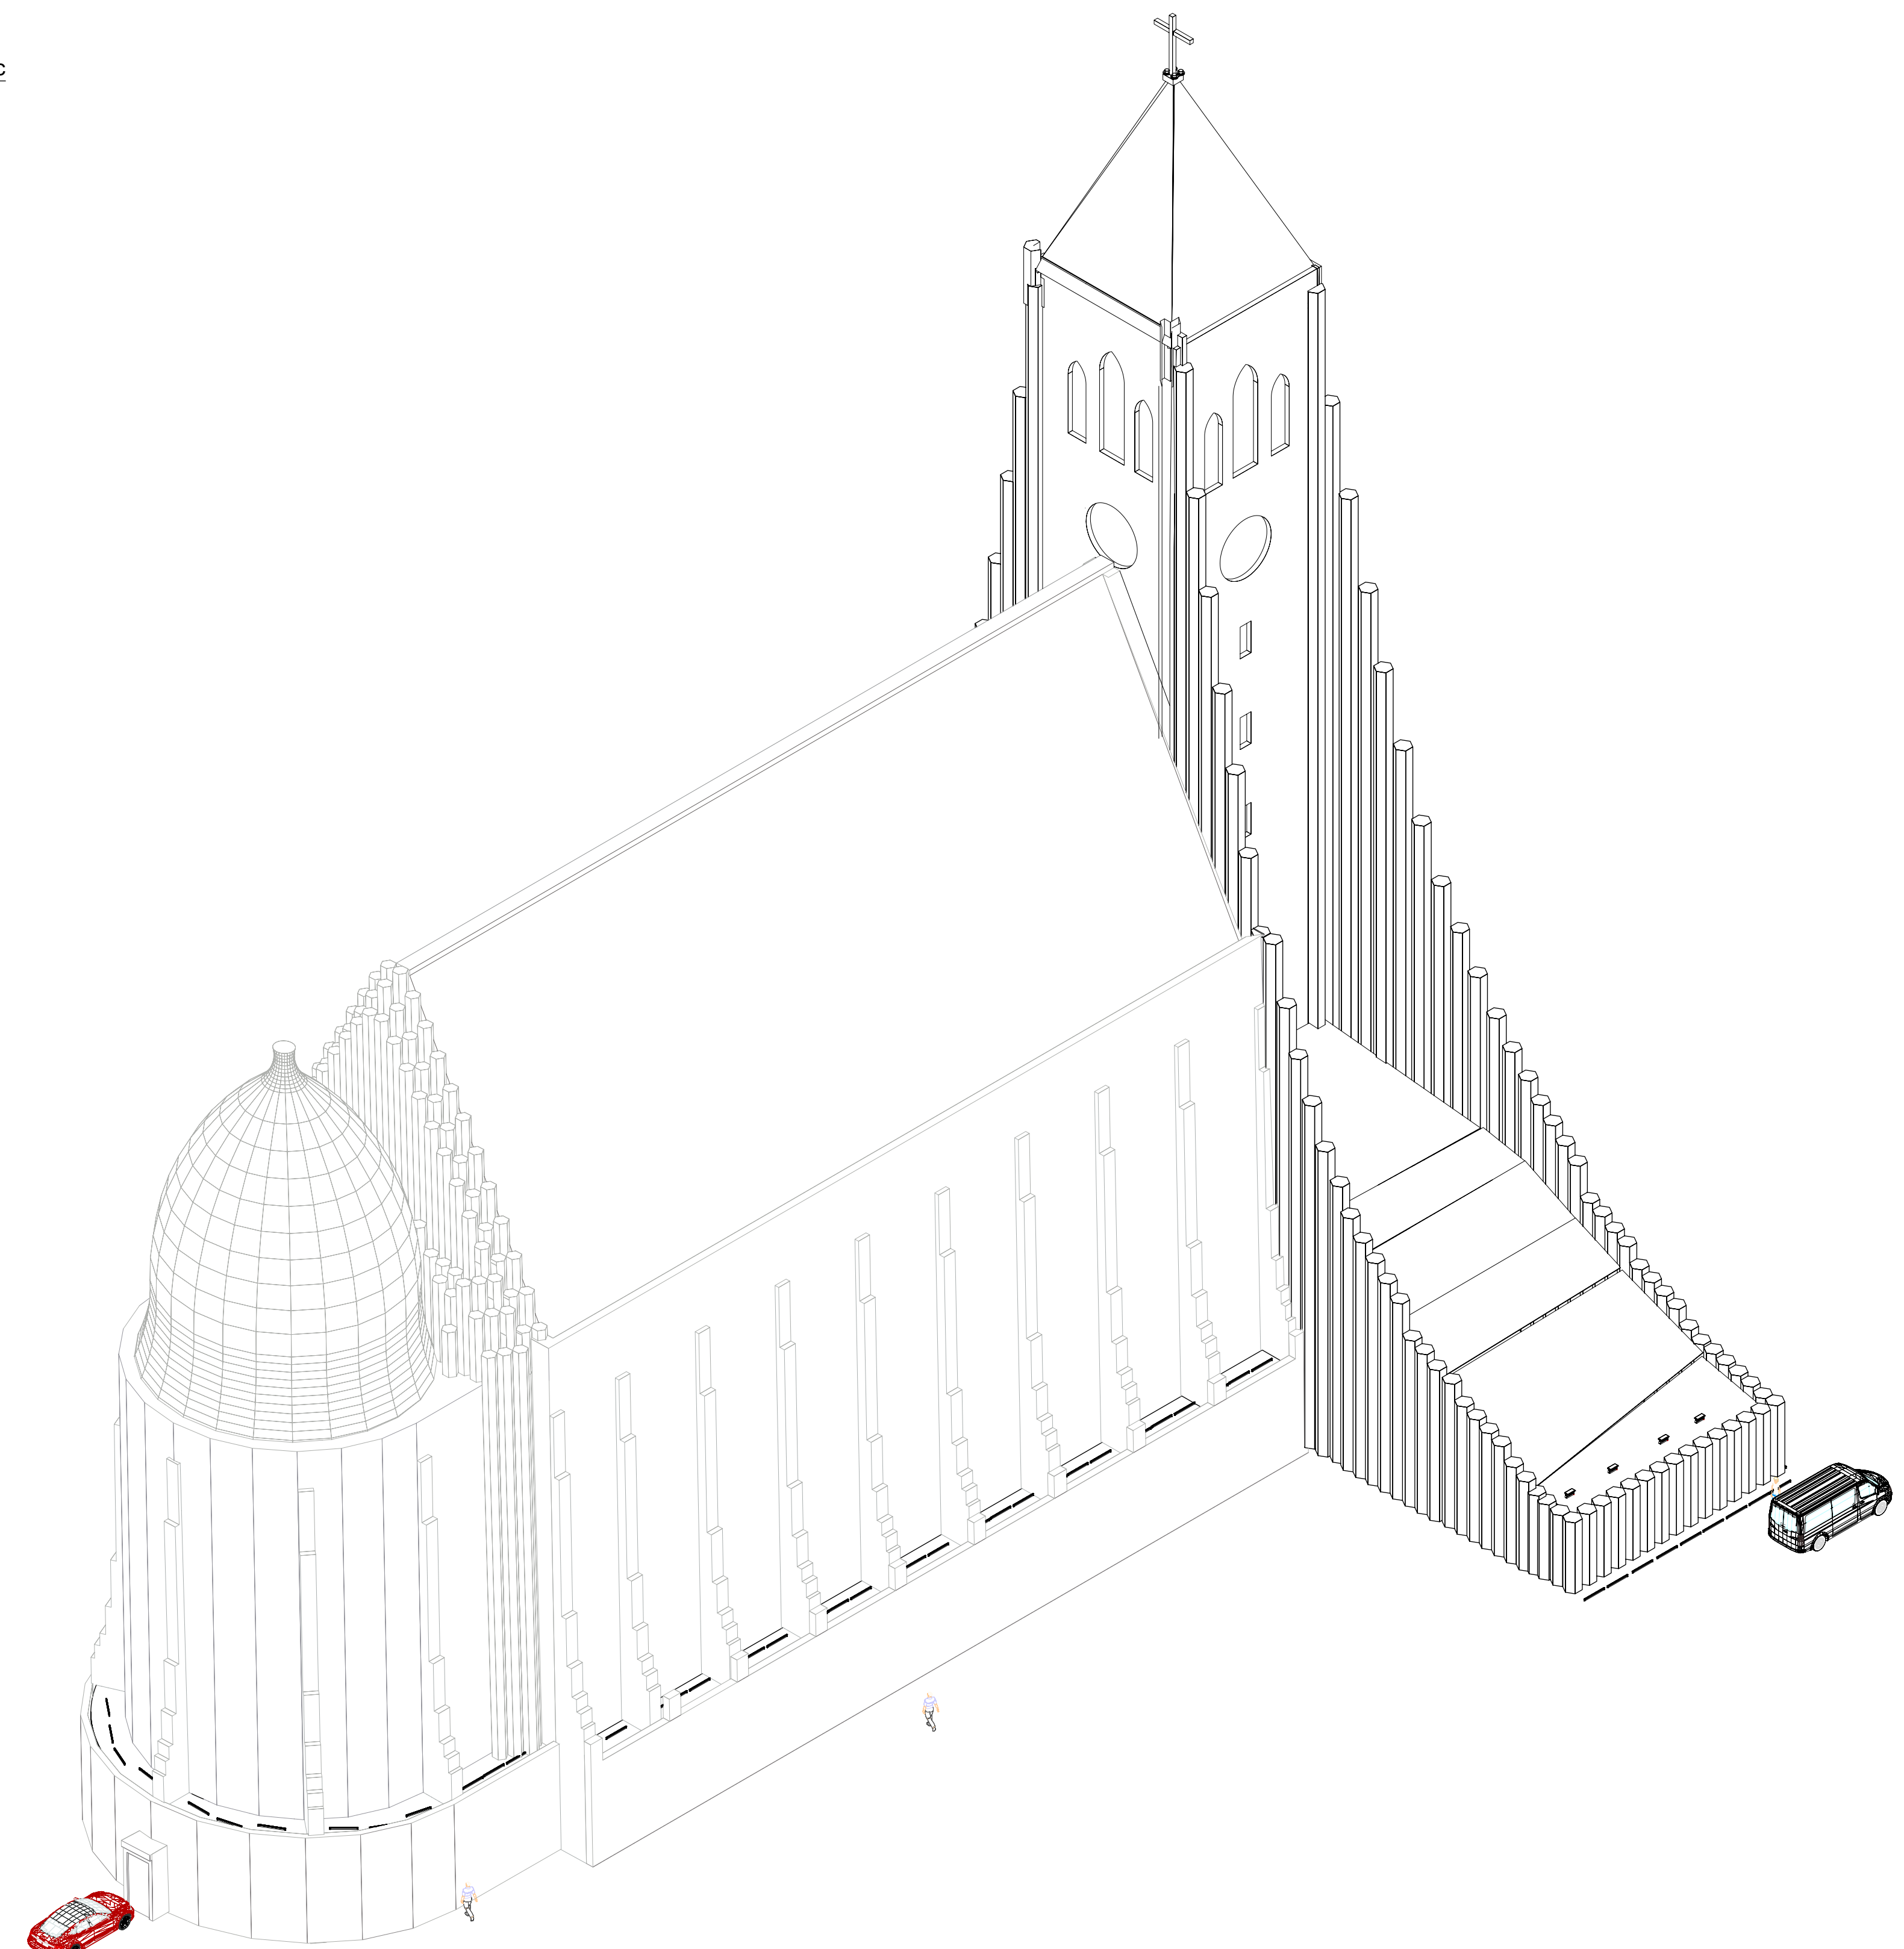

4 Left Rear Isometric
Scale: 1/16" = 1'-0"

- Key**
- ProPoint RGBW Wall Washer 40W
 - Allegro Linear AC 1200
 - SGM I-5
 - SGM G-Spot Turbo POI

No.	Date	Issue Notes



Design Firm: Kahkonen, Smith and Uncein

Project Title: Hallgrimskirkja

Sheet Title: Isometric Views

Drawn By: Ulisse Kahkonen, Thomas Uncein

Date: 12/15/20

CAD File Name: Hallgrimskirkja Final Drafting Package.vwx

Scale: 1/16" = 1'-0"
9 of 9